

bDot Architecture, Inc.
P: 205.438.8053 | E: info@bdot.com
130.416 Street South, Suite 102 | Birmingham, AL 35222

PRELIMINARY
DRAWINGS
NOT FOR
CONSTRUCTION

©2024 bDot Architecture, Inc.
Drawings, design concepts, and written materials shall not be used or reproduced in whole or part in any form or format without prior written consent of bDot Architecture, Inc.

All discrepancies in the construction drawings and / or specifications not brought to the architect's attention during the bid or pricing phase of the project shall become subject to the interpretation of the architect during the construction process and will not be grounds for a change order of any kind.


PANERA BREAD
SHELL BUILDING PACKAGE
BRYANT, ARKANSAS

GENERAL NOTES

1. INSTALL OVERSIZED BACKER ROD AND SEALANT AROUND ALL CLADDING PENETRATIONS TO SEAL TO THE AIR AND WATER BARRIER AND TO THE CLADDING, TYPICAL.
2. INSTALL OVERSIZED BACKER ROD AND SEALANT AT CLADDING TRANSITIONS, TYPICAL.
3. INSTALL STOREFRONT IN FULL BED OF SEALANT, TYPICAL.
4. ADJUST BRICK JOINTS TO ACCOMMODATE COURSING AS NEEDED.
5. FIRE DEPARTMENT ACCESS BOX TO BE INSTALLED ADJACENT SERVICE DOOR. COORDINATE LOCATION WITH LOCAL FIRE DEPARTMENT.
6. HOSE BIBB | RECESSED STAINLESS STEEL BOX. REFER TO PLUMBING DRAWINGS FOR LOCATION AND ADDITIONAL INFORMATION.
7. BUILDING ADDRESS SIGN: VERIFY SIZE, LOCATION, AND STYLE WITH LOCAL FIRE DEPARTMENT.
8. ELECTRICAL SWITCHGEAR CABINETS TO BE PAINTED TO MATCH EIFS. REFER TO ELECTRICAL FOR FURTHER INFORMATION.
9. GAS METER: ONCE GAS LINES ARE INSTALLED, PAINT TO MATCH ADJACENT BRICK. VERIFY WITH TENANT. REFER TO PLUMBING DRAWINGS FOR FURTHER INFORMATION.
10. SECURITY CAMERAS: G.C. TO PROVIDE ROUGH-IN LOCATIONS. COORDINATE ROUGH-IN LOCATIONS AND HEIGHT WITH TENANT PRIOR TO INSTALLATION.
11. BOLLARDS: CONCRETE BOARDS TO BE PAINTED SAFETY YELLOW. SEE CIVIL FOR LOCATIONS AND ADDITIONAL INFORMATION.


KEYED NOTES

- 3.01 NEW SIGNAGE; PROVIDED AND INSTALLED BY TENANT SIGN VENDOR UNDER SEPARATE PERMIT; G.C. TO PROVIDE BLOCKING IN WALL FOR SIGN AND PROVIDE ACCESS PANEL ON BACKSIDE OF PARAPET FOR ACCESS AS REQUIRED. (UNDER SEPARATE SIGNAGE PERMIT).
- 3.02 PRE-FINISHED METAL COPING | FINISH: MATTE, COLOR: CHARCOAL TO MATCH RAL 7043.
- 3.04 MAIN ENTRANCE SPACE/EXIT. DOOR TO MATCH STOREFRONT COLOR.
- 3.06 HOLLOW METAL SERVICE DOOR. | PAINT TO MATCH ADJACENT WALL COLOR. (P1)
- 3.07 DRIVE-THRU WINDOW | MFR: QUIKSERV | MODEL: FM42E | COLOR TO MATCH STOREFRONT.
- 3.10 CONTINUOUS V-GROOVE REVEAL
- 3.11 PRE-MANUFACTURED ALUMINUM CANOPY W/ TIE RODS WITH FINISHED UNDERSIDE. INSTALLED BY G.C. PER MANUFACTURER'S RECOMMENDATIONS. MANF: API, INC. COLOR: DARK GREEN, FMS 2411C. VERIFY WITH TENANT. CANOPY TO INCLUDE LIGHTING, INTERNAL DRAIN (TO TIE INTO STORM)
- 3.18 NICKEL BRONZE NOZZLE RWJ/OVERFLOW DRAIN THRU ROOF, MIN. 12" ABOVE GRADE.
- 3.36 PREMANUFACTURED RIBBED PANEL ROOF EQUIPMENT SCREENING, MFR: ROOFSCREEN MANUFACTURING, COLOR: TO MATCH F224.
- BR-1 BRICK - UTILITY FACE BRICK, SIZE: 3-5/8"W X 3-5/8"H X 11-5/8"L, COLOR: TO MATCH SANTIAGO CREATIVE MATERIALS BLEND, HORIZONTAL STACK BOND. MORTAR TO BE LATICRETE MVIS POINTING MORTAR, #40 TERRACOTTA.
- BR-2 BRICK - UTILITY FACE BRICK, SIZE: 3-5/8"W X 3-5/8"H X 11-5/8"L, COLOR: TO MATCH GOLDEN BLUFF CREATIVE MATERIALS, SOLDIER COURSE. MORTAR TO BE LATICRETE MVIS POINTING MORTAR, #40 LATTE.
- EIFS-1 EXTERIOR INSULATION FINISH SYSTEM, PRODUCT: DRYVIT 'OUTSULATION PLUS MD' EIFS WITH MOISTURE DRAINAGE SYSTEM, COLOR: COLOR MATCH TO DRYVIT #105 SUEDE, TEXTURE: DRYVIT 'LYMESTONE'.
- ES-1 UNIT-MOUNTED PREFABRICATED METAL ROOF EQUIPMENT SCREENS UNLESS POST-MOUNTED SCREEN IS REQUIRED. CONTRACTOR TO VERIFY IF ROOFTOP EQUIPMENT LAYOUT CAN UTILIZE UNIT-MOUNTED SCREEN SYSTEM WITH MANUFACTURER.
- SF-1 SPECIAL FINISH - NICHHA VINTAGEWOOD ARCHITECTURAL WALL PANEL, COLOR: SPRUCE - VERIFY WITH TENANT.
- SF-2 SPECIAL FINISH - NICHHA RIBBED ARCHITECTURAL WALL PANEL WITH MATCHING NICHHA 3-5" CORNER PIECES AT ALL CORNERS. CUSTOM COLOR: "PANERA GREEN" - VERIFY WITH TENANT.
- SF-5-1 ALUMINUM STOREFRONT SYSTEM WITH 1" INSULATED GLAZING, PRODUCT: TRIFAB 451 FRAMING SYSTEM, FINISH: DARK BRONZE FINISH ANODIZED ALUMINUM.

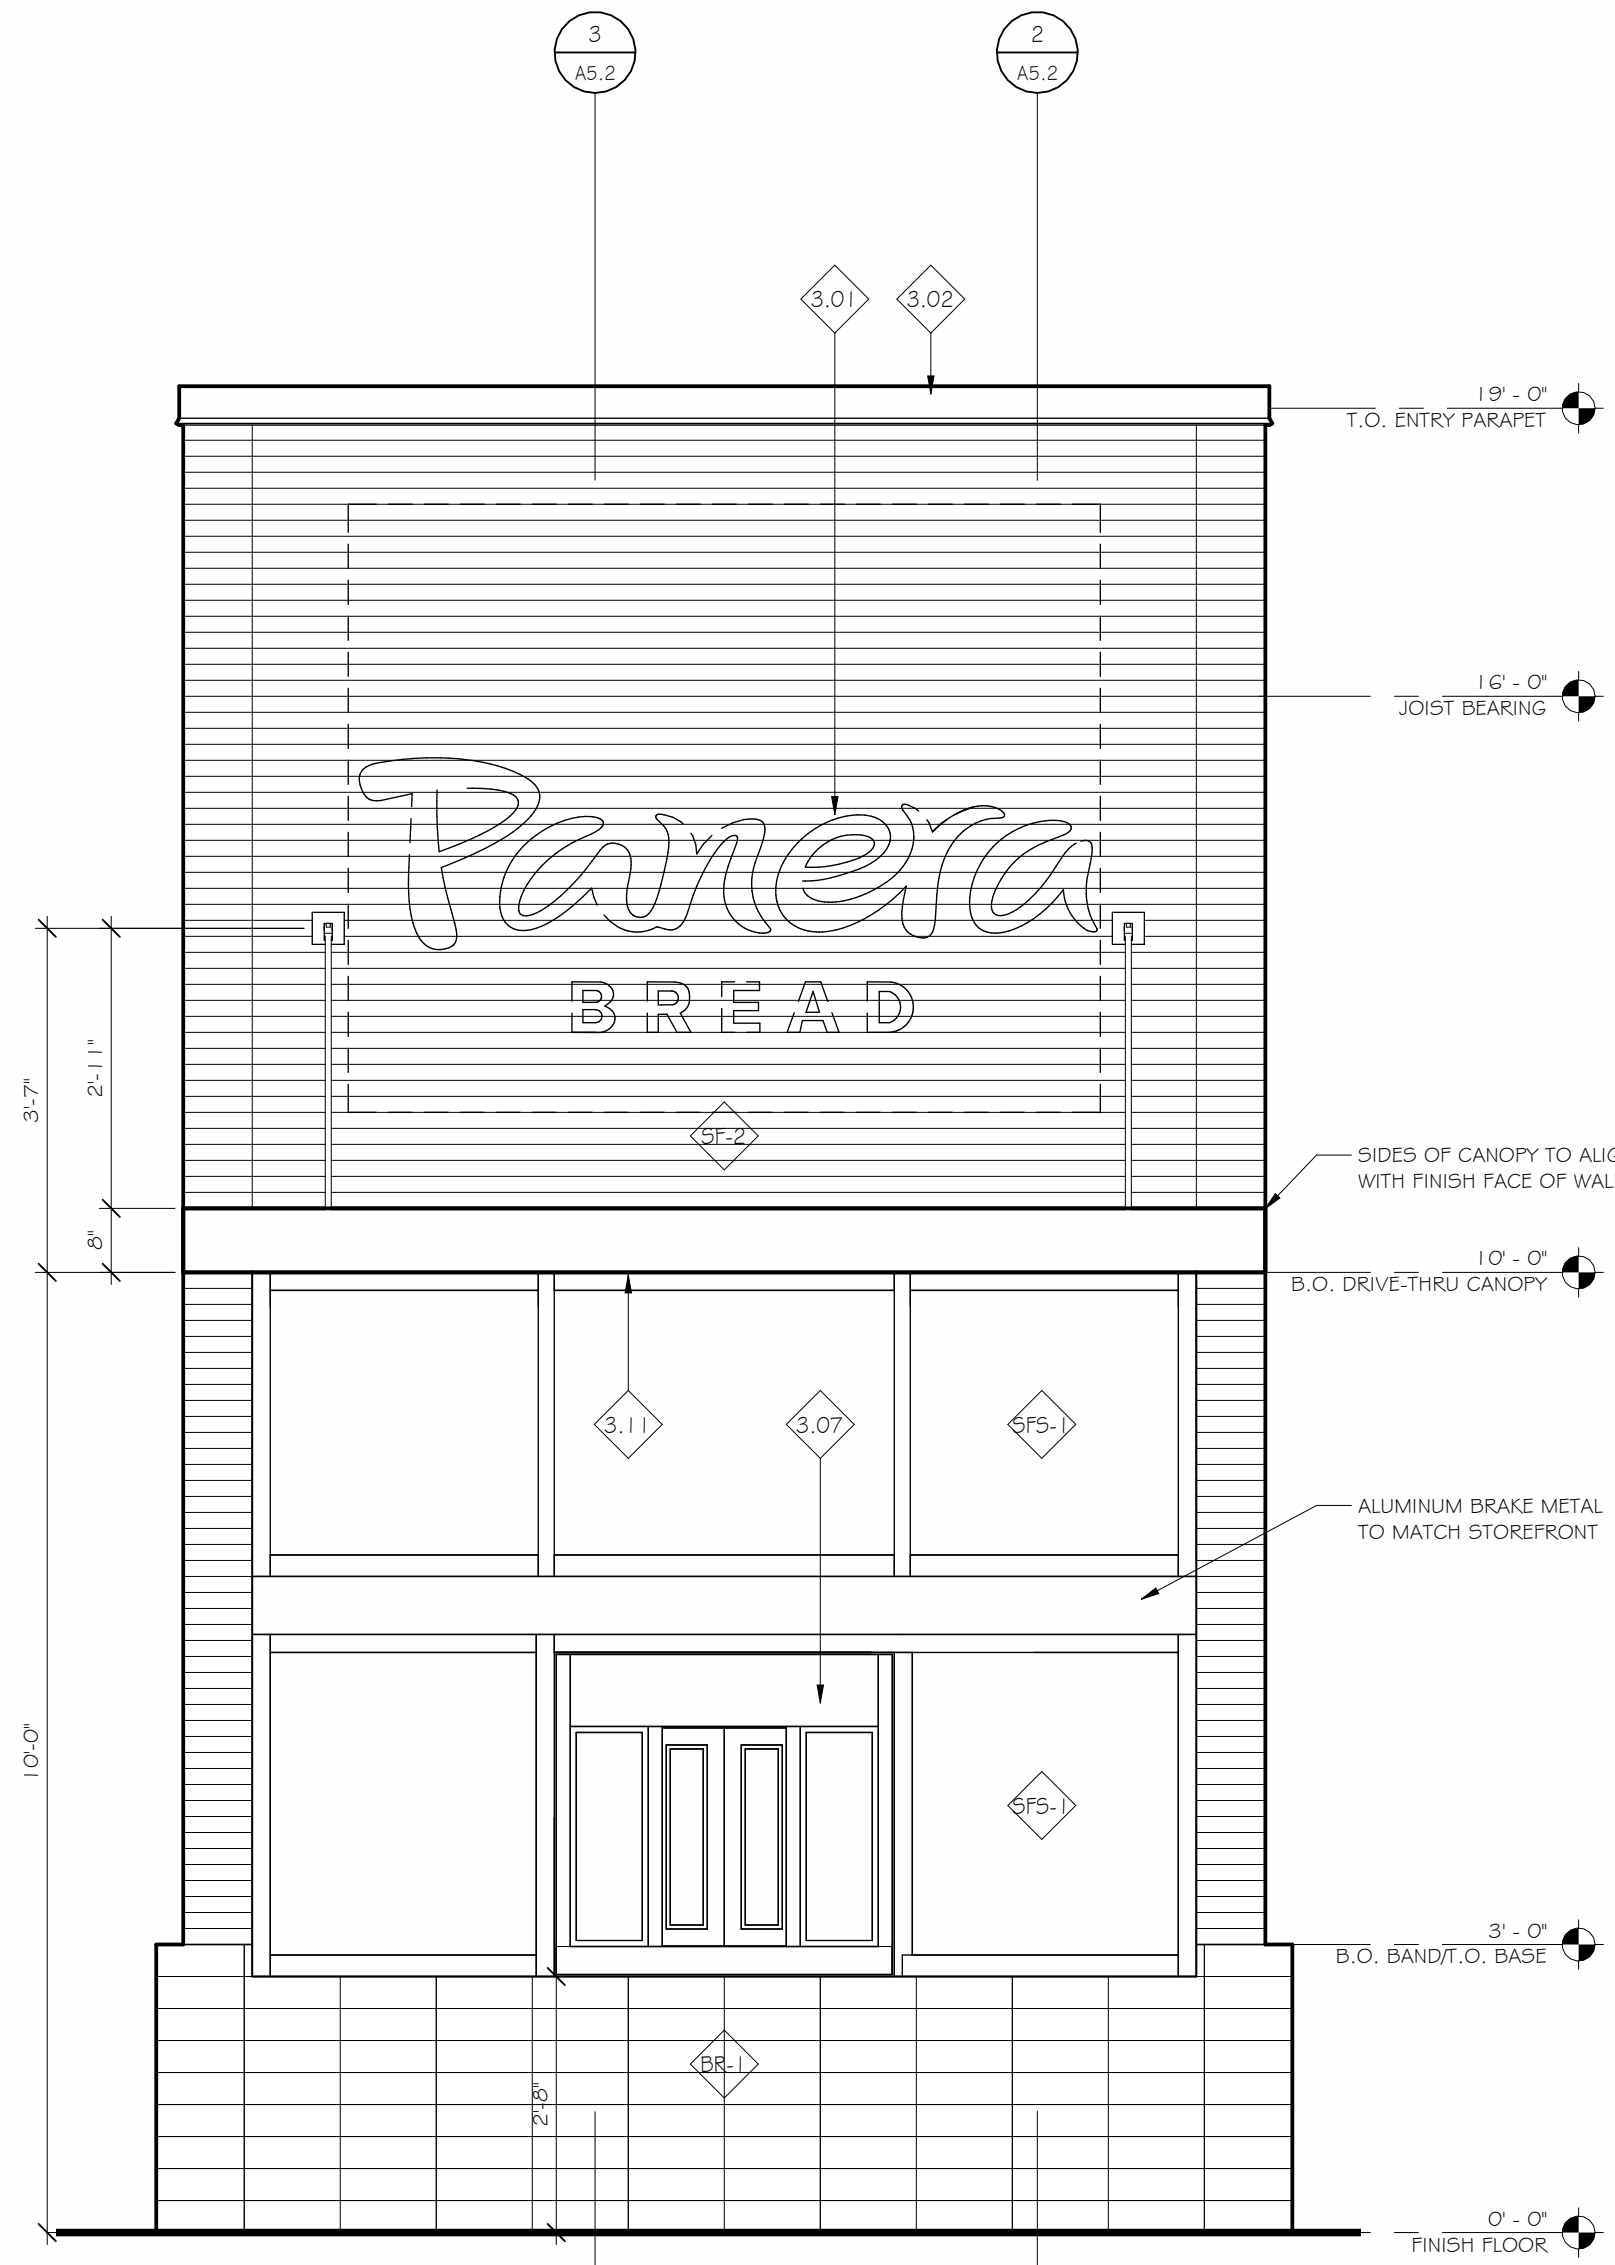

CANOPY VENDOR:
MICHAEL CALDERONE - NATIONAL ACCOUNT MANAGER
AMERICAN PRODUCTS, INC. (API)
13909 LYNNMAR BOULEVARD - TAMPA, FL 33626
PHONE: 813.925.0144 - FAX: 813.925.1414
M.CALDERONE@AMERICANPRODUCTS.COM -
WWW.AMERICANPRODUCTS.COM
(WINKNOTWOOD (OR SIMILAR) UNDERSIDE FINISH/SOFT)


3 DRIVE THRU DETAIL
1/2" = 1'-0"

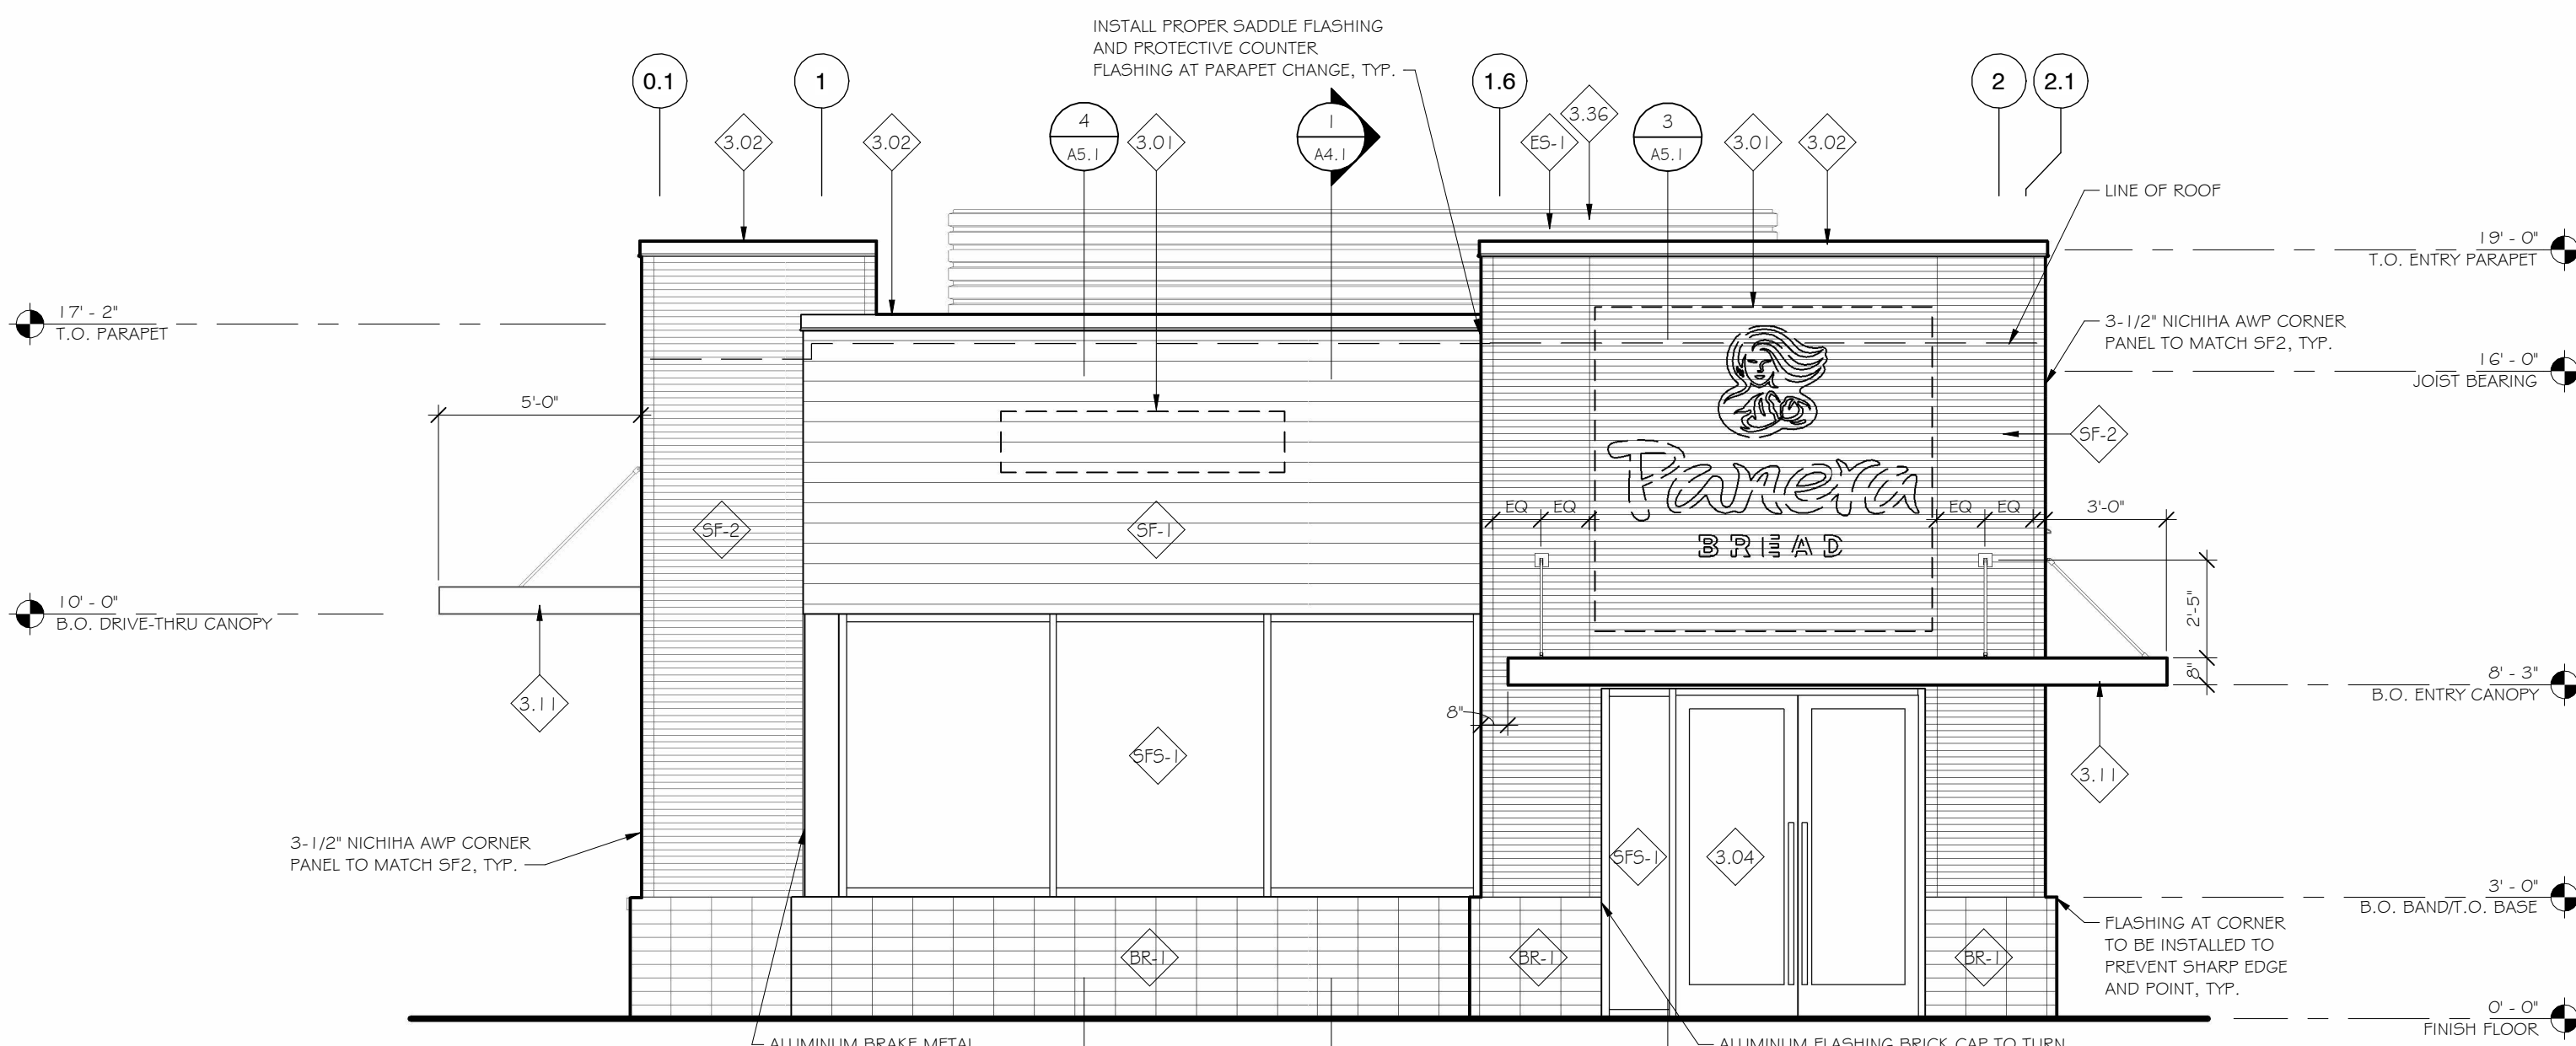

CANOPY VENDOR:
MICHAEL CALDERONE - NATIONAL ACCOUNT MANAGER
AMERICAN PRODUCTS, INC. (API)
13909 LYNNMAR BOULEVARD - TAMPA, FL 33626
PHONE: 813.925.0144 - FAX: 813.925.1414
M.CALDERONE@AMERICANPRODUCTS.COM -
WWW.AMERICANPRODUCTS.COM
(WINKNOTWOOD (OR SIMILAR) UNDERSIDE FINISH/SOFT)

2 SOUTH ELEVATION
1/4" = 1'-0"

MOCK UP NOTE:
APPROVED BRICK MOCK UP REQUIRED BEFORE
BRICK INSTALLATION TO START. CONTRACTOR
TO BUILD 2x2' BRICK CORNER DETAIL MOCK UP
THAT SHOWS MITERED BRICK CORNER DETAIL
AND ALUMINUM BRICK CAP TURNING THE
CORNER. FLASHING AT CORNER TO BE
INSTALLED TO PREVENT SHARP EDGE OF POINT.

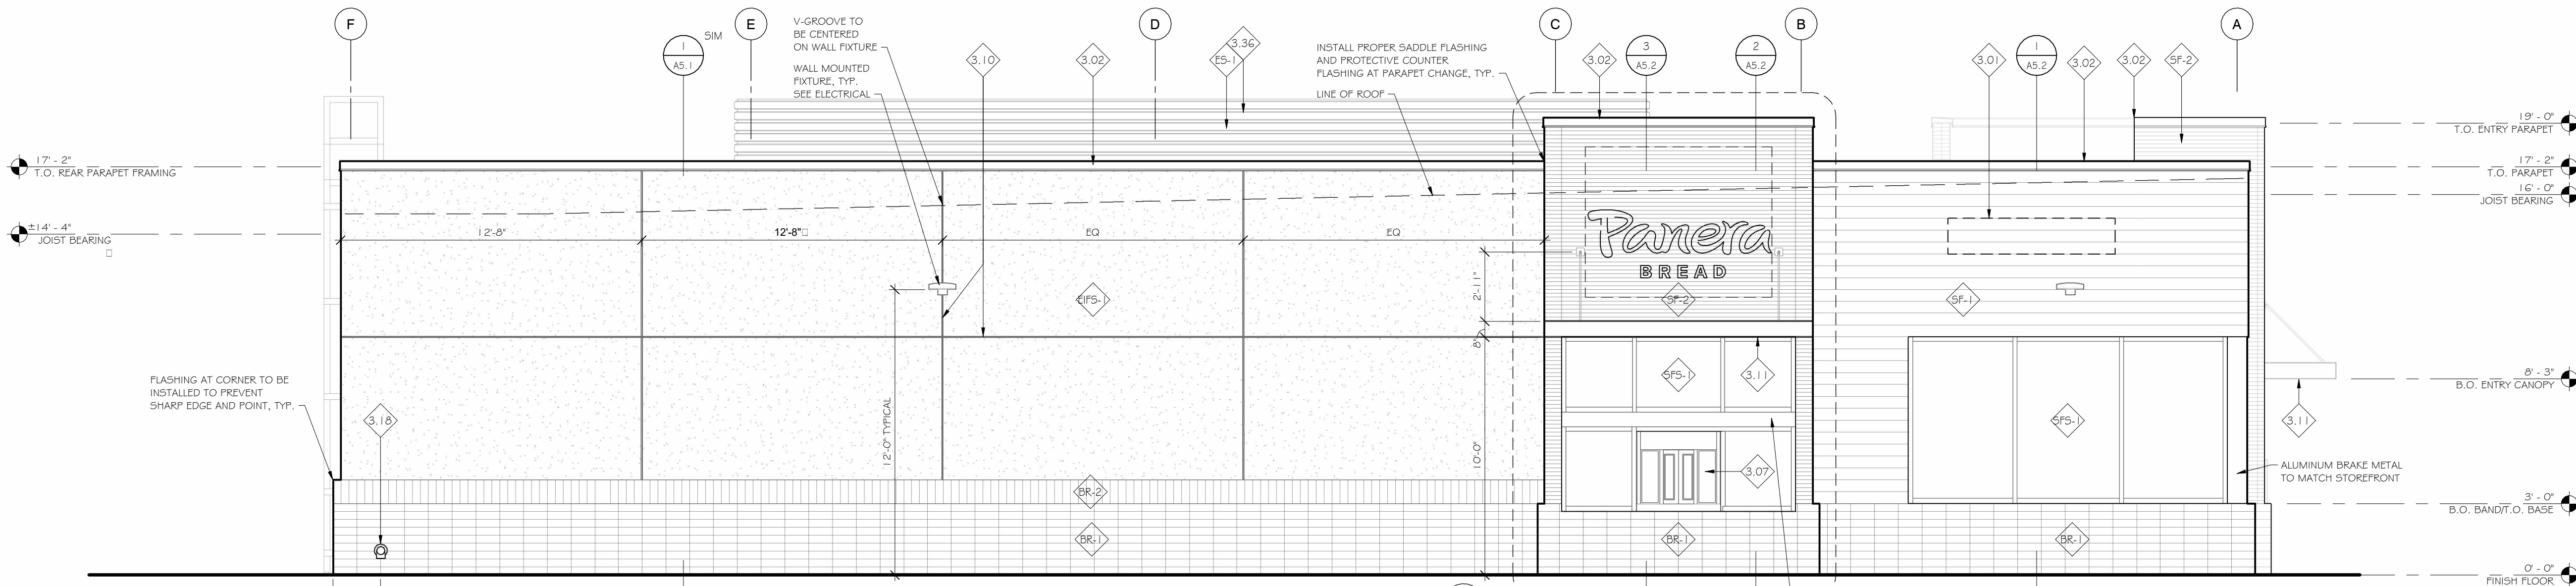

CANOPY VENDOR:
MICHAEL CALDERONE - NATIONAL ACCOUNT MANAGER
AMERICAN PRODUCTS, INC. (API)
13909 LYNNMAR BOULEVARD - TAMPA, FL 33626
PHONE: 813.925.0144 - FAX: 813.925.1414
M.CALDERONE@AMERICANPRODUCTS.COM -
WWW.AMERICANPRODUCTS.COM
(WINKNOTWOOD (OR SIMILAR) UNDERSIDE FINISH/SOFT)

MOCK UP NOTE:
APPROVED BRICK MOCK UP REQUIRED BEFORE
BRICK INSTALLATION TO START. CONTRACTOR
TO BUILD 2x2' BRICK CORNER DETAIL MOCK UP
THAT SHOWS MITERED BRICK CORNER DETAIL
AND ALUMINUM BRICK CAP TURNING THE
CORNER. FLASHING AT CORNER TO BE
INSTALLED TO PREVENT SHARP EDGE OF POINT.

1 WEST ELEVATION
1/4" = 1'-0"

REVISIONS:


DATE:
10/04/2024

PROJECT NUMBER:
2421

SHEET NAME:
EXTERIOR ELEVATIONS

SHEET NUMBER:

A3.1

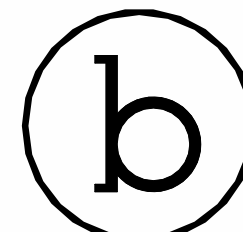

bDot Architecture, Inc.
P: 205.438.8053 | E: info@bdot.com
130.416 Street South, Suite 102 | Birmingham, AL 35222

PRELIMINARY
DRAWINGS
NOT FOR
CONSTRUCTION

©2024 bDot Architecture, Inc.
Drawings, design concepts, and written materials shall not be used or reproduced in whole or part in any form or format without prior written consent of bDot Architecture, Inc.

All discrepancies in the construction drawings and / or specifications not brought to the architect's attention during the bid or pricing phase of the project shall become subject to the interpretation of the architect during the construction process and will not be grounds for a change order of any kind.


PANERA BREAD
SHELL BUILDING PACKAGE
BRYANT, ARKANSAS

GENERAL NOTES


1. INSTALL OVERSIZED BACKER ROD AND SEALANT AROUND ALL CLADDING PENETRATIONS TO SEAL TO THE AIR AND WATER BARRIER AND TO THE CLADDING, TYPICAL.
2. INSTALL OVERSIZED BACKER ROD AND SEALANT AT CLADDING TRANSITIONS, TYPICAL.
3. INSTALL STOREFRONT IN FULL BED OF SEALANT, TYPICAL.
4. ADJUST BRICK JOINTS TO ACCOMMODATE COURSING AS NEEDED.
5. FIRE DEPARTMENT ACCESS BOX TO BE INSTALLED ADJACENT SERVICE DOOR. COORDINATE LOCATION WITH LOCAL FIRE DEPARTMENT.
6. HOSE BIBB | RECESSED STAINLESS STEEL BOX. REFER TO PLUMBING DRAWINGS FOR LOCATION AND ADDITIONAL INFORMATION.
7. BUILDING ADDRESS SIGN: VERIFY SIZE, LOCATION, AND STYLE WITH LOCAL FIRE DEPARTMENT.
8. ELECTRICAL SWITCHGEAR CABINETS TO BE PAINTED TO MATCH EIFS. REFER TO ELECTRICAL FOR FURTHER INFORMATION.
9. GAS METER: ONCE GAS LINES ARE INSTALLED, PAINT TO MATCH ADJACENT BRICK. VERIFY WITH TENANT. REFER TO PLUMBING DRAWINGS FOR FURTHER INFORMATION.
10. SECURITY CAMERAS: G.C. TO PROVIDE ROUGH-IN LOCATIONS. COORDINATE ROUGH-IN LOCATIONS AND HEIGHT WITH TENANT PRIOR TO INSTALLATION.
11. BOLLARDS: CONCRETE BOARDS TO BE PAINTED SAFETY YELLOW. SEE CIVIL FOR LOCATIONS AND ADDITIONAL INFORMATION.

KEYED NOTES


- 3.01 NEW SIGNAGE; PROVIDED AND INSTALLED BY TENANT SIGN VENDOR UNDER SEPARATE PERMIT; G.C. TO PROVIDE BLOCKING IN WALL FOR SIGN AND PROVIDE ACCESS PANEL ON BACKSIDE OF PARAPET FOR ACCESS AS REQUIRED. (UNDER SEPARATE SIGNAGE PERMIT).
- 3.02 PRE-FINISHED METAL COPING | FINISH: MATTE, COLOR: CHARCOAL TO MATCH RAL 7043.
- 3.04 MAIN ENTRANCE SPACEEXIT. DOOR TO MATCH STOREFRONT COLOR.
- 3.06 HOLLOW METAL SERVICE DOOR. | PAINT TO MATCH ADJACENT WALL COLOR. (P1)
- 3.07 DRIVE-THRU WINDOW | MFR: QUIKSERV | MODEL: FM42E | COLOR TO MATCH STOREFRONT.
- 3.10 CONTINUOUS V-GROOVE REVEAL
- 3.11 PRE-MANUFACTURED ALUMINUM CANOPY W/ TIE RODS WITH FINISHED UNDERSIDE. INSTALLED BY G.C. PER MANUFACTURER'S RECOMMENDATIONS. MANIF: API, INC. COLOR: DARK GREEN, FMS 2411C. VERIFY WITH TENANT. CANOPY TO INCLUDE LIGHTING, INTERNAL DRAIN (TO TIE INTO STORM).
- 3.18 NICKEL BRONZE NOZZLE RWLOVERFLOW DRAIN THRU ROOF, MIN. 12" ABOVE GRADE.
- 3.36 PREMANUFACTURED RIBBED PANEL ROOF EQUIPMENT SCREENING, MFR: ROOFSCREEN MANUFACTURING, COLOR: TO MATCH F224.
- BR-1 BRICK - UTILITY FACE BRICK, SIZE: 3-5/8"W X 3-5/8"H X 1 1/4", COLOR: TO MATCH SANTIAGO CREATIVE MATERIALS BLEND, HORIZONTAL STACK BOND. MORTAR TO BE LATICRETE MVIS POINTING MORTAR, #58 TERRACOTTA.
- BR-2 BRICK - UTILITY FACE BRICK, SIZE: 3-5/8"W X 3-5/8"H X 1 1/4", COLOR: TO MATCH GOLDEN BLUFF CREATIVE MATERIALS, SOLDIER COURSE. MORTAR TO BE LATICRETE MVIS POINTING MORTAR, #40 LATTE.
- EIFS-1 EXTERIOR INSULATION FINISH SYSTEM, PRODUCT: DRYVIT 'OUTSULATION PLUS MD' EIFS WITH MOISTURE DRAINAGE SYSTEM, COLOR: COLOR MATCH TO DRYVIT #105 SUEDE, TEXTURE: DRYVIT 'LYMESTONE'.
- ES-1 UNIT-MOUNTED PREFABRICATED METAL ROOF EQUIPMENT SCREENS UNLESS POST-MOUNTED SCREEN IS REQUIRED. CONTRACTOR TO VERIFY IF ROOFTOP EQUIPMENT LAYOUT CAN UTILIZE UNIT-MOUNTED SCREEN SYSTEM WITH MANUFACTURER.
- SF-1 SPECIAL FINISH - NICHHA VINTAGEWOOD ARCHITECTURAL WALL PANEL, COLOR: SPRUCE - VERIFY WITH TENANT.
- SF-2 SPECIAL FINISH - NICHHA RIBBED ARCHITECTURAL WALL PANEL WITH MATCHING NICHHA 3-5" CORNER PIECES AT ALL CORNERS. CUSTOM COLOR: "PANERA GREEN" - VERIFY WITH TENANT.
- SF5-1 ALUMINUM STOREFRONT SYSTEM WITH 1" INSULATED GLAZING, PRODUCT: TRIFAB 451 FRAMING SYSTEM, FINISH: DARK BRONZE FINISH ANODIZED ALUMINUM.

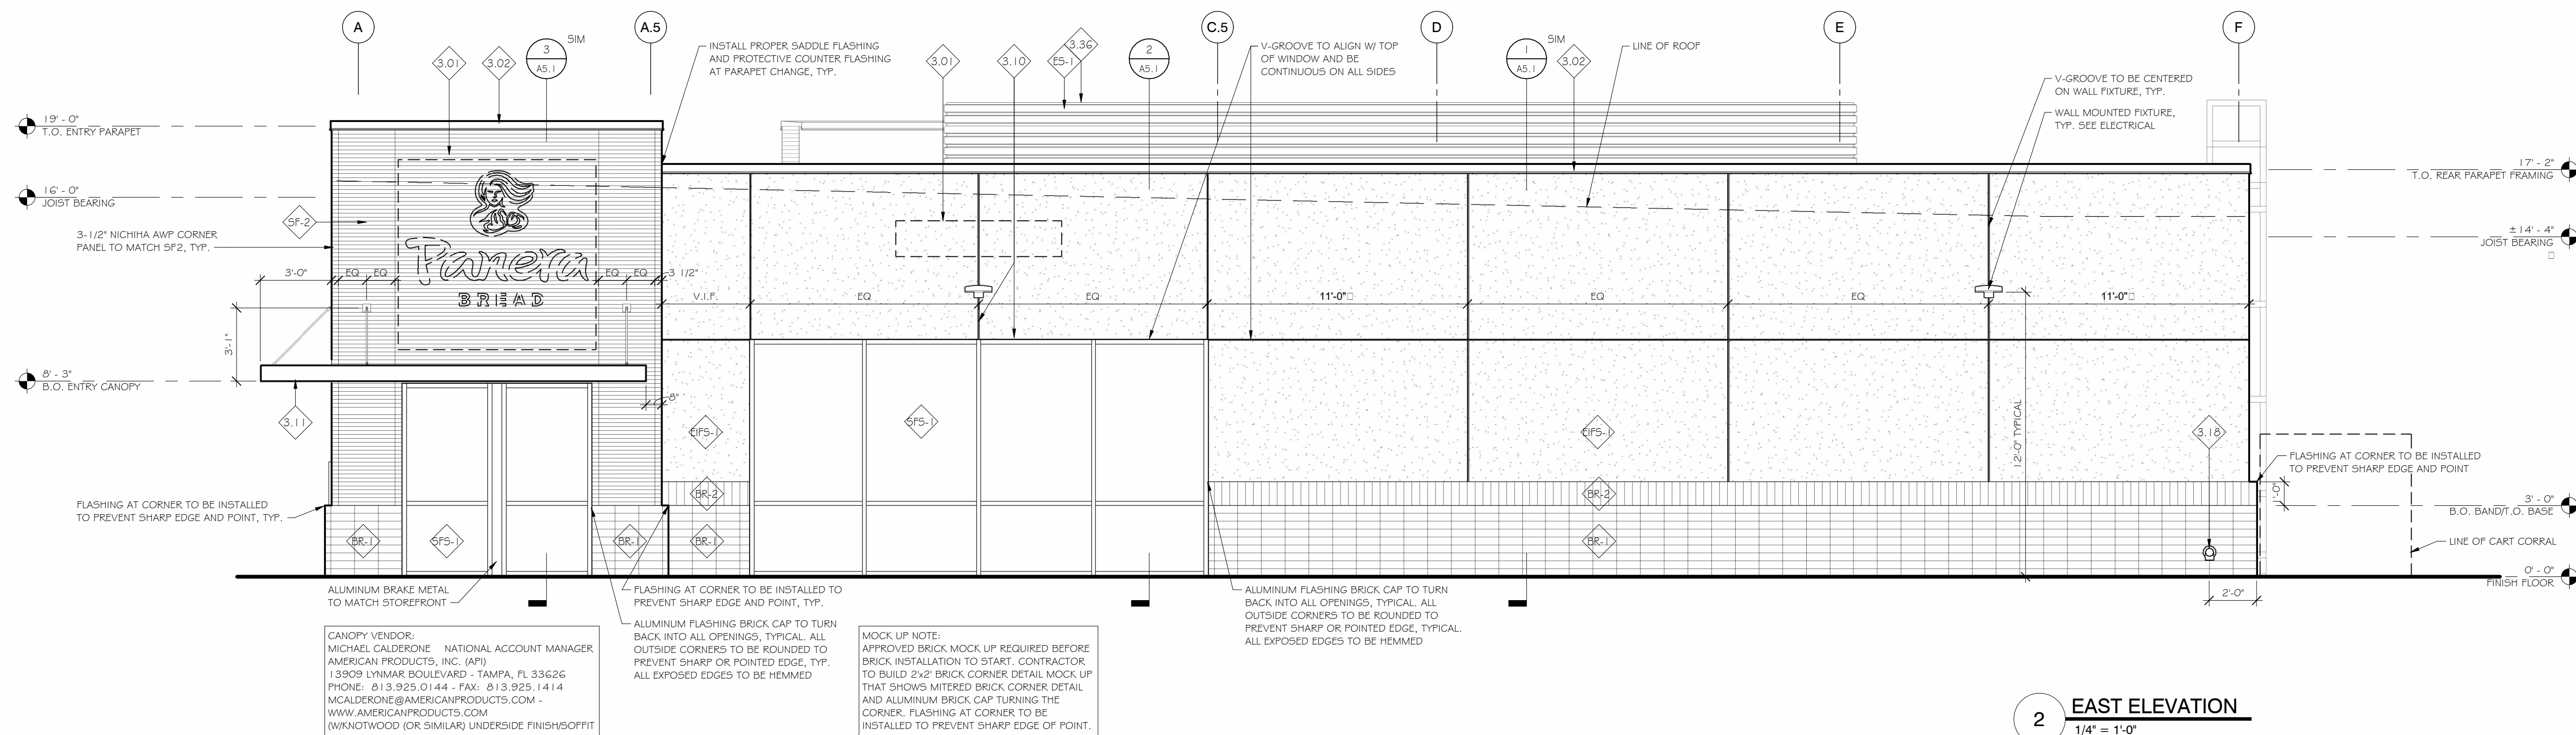

2 EAST ELEVATION
1/4" = 1'-0"

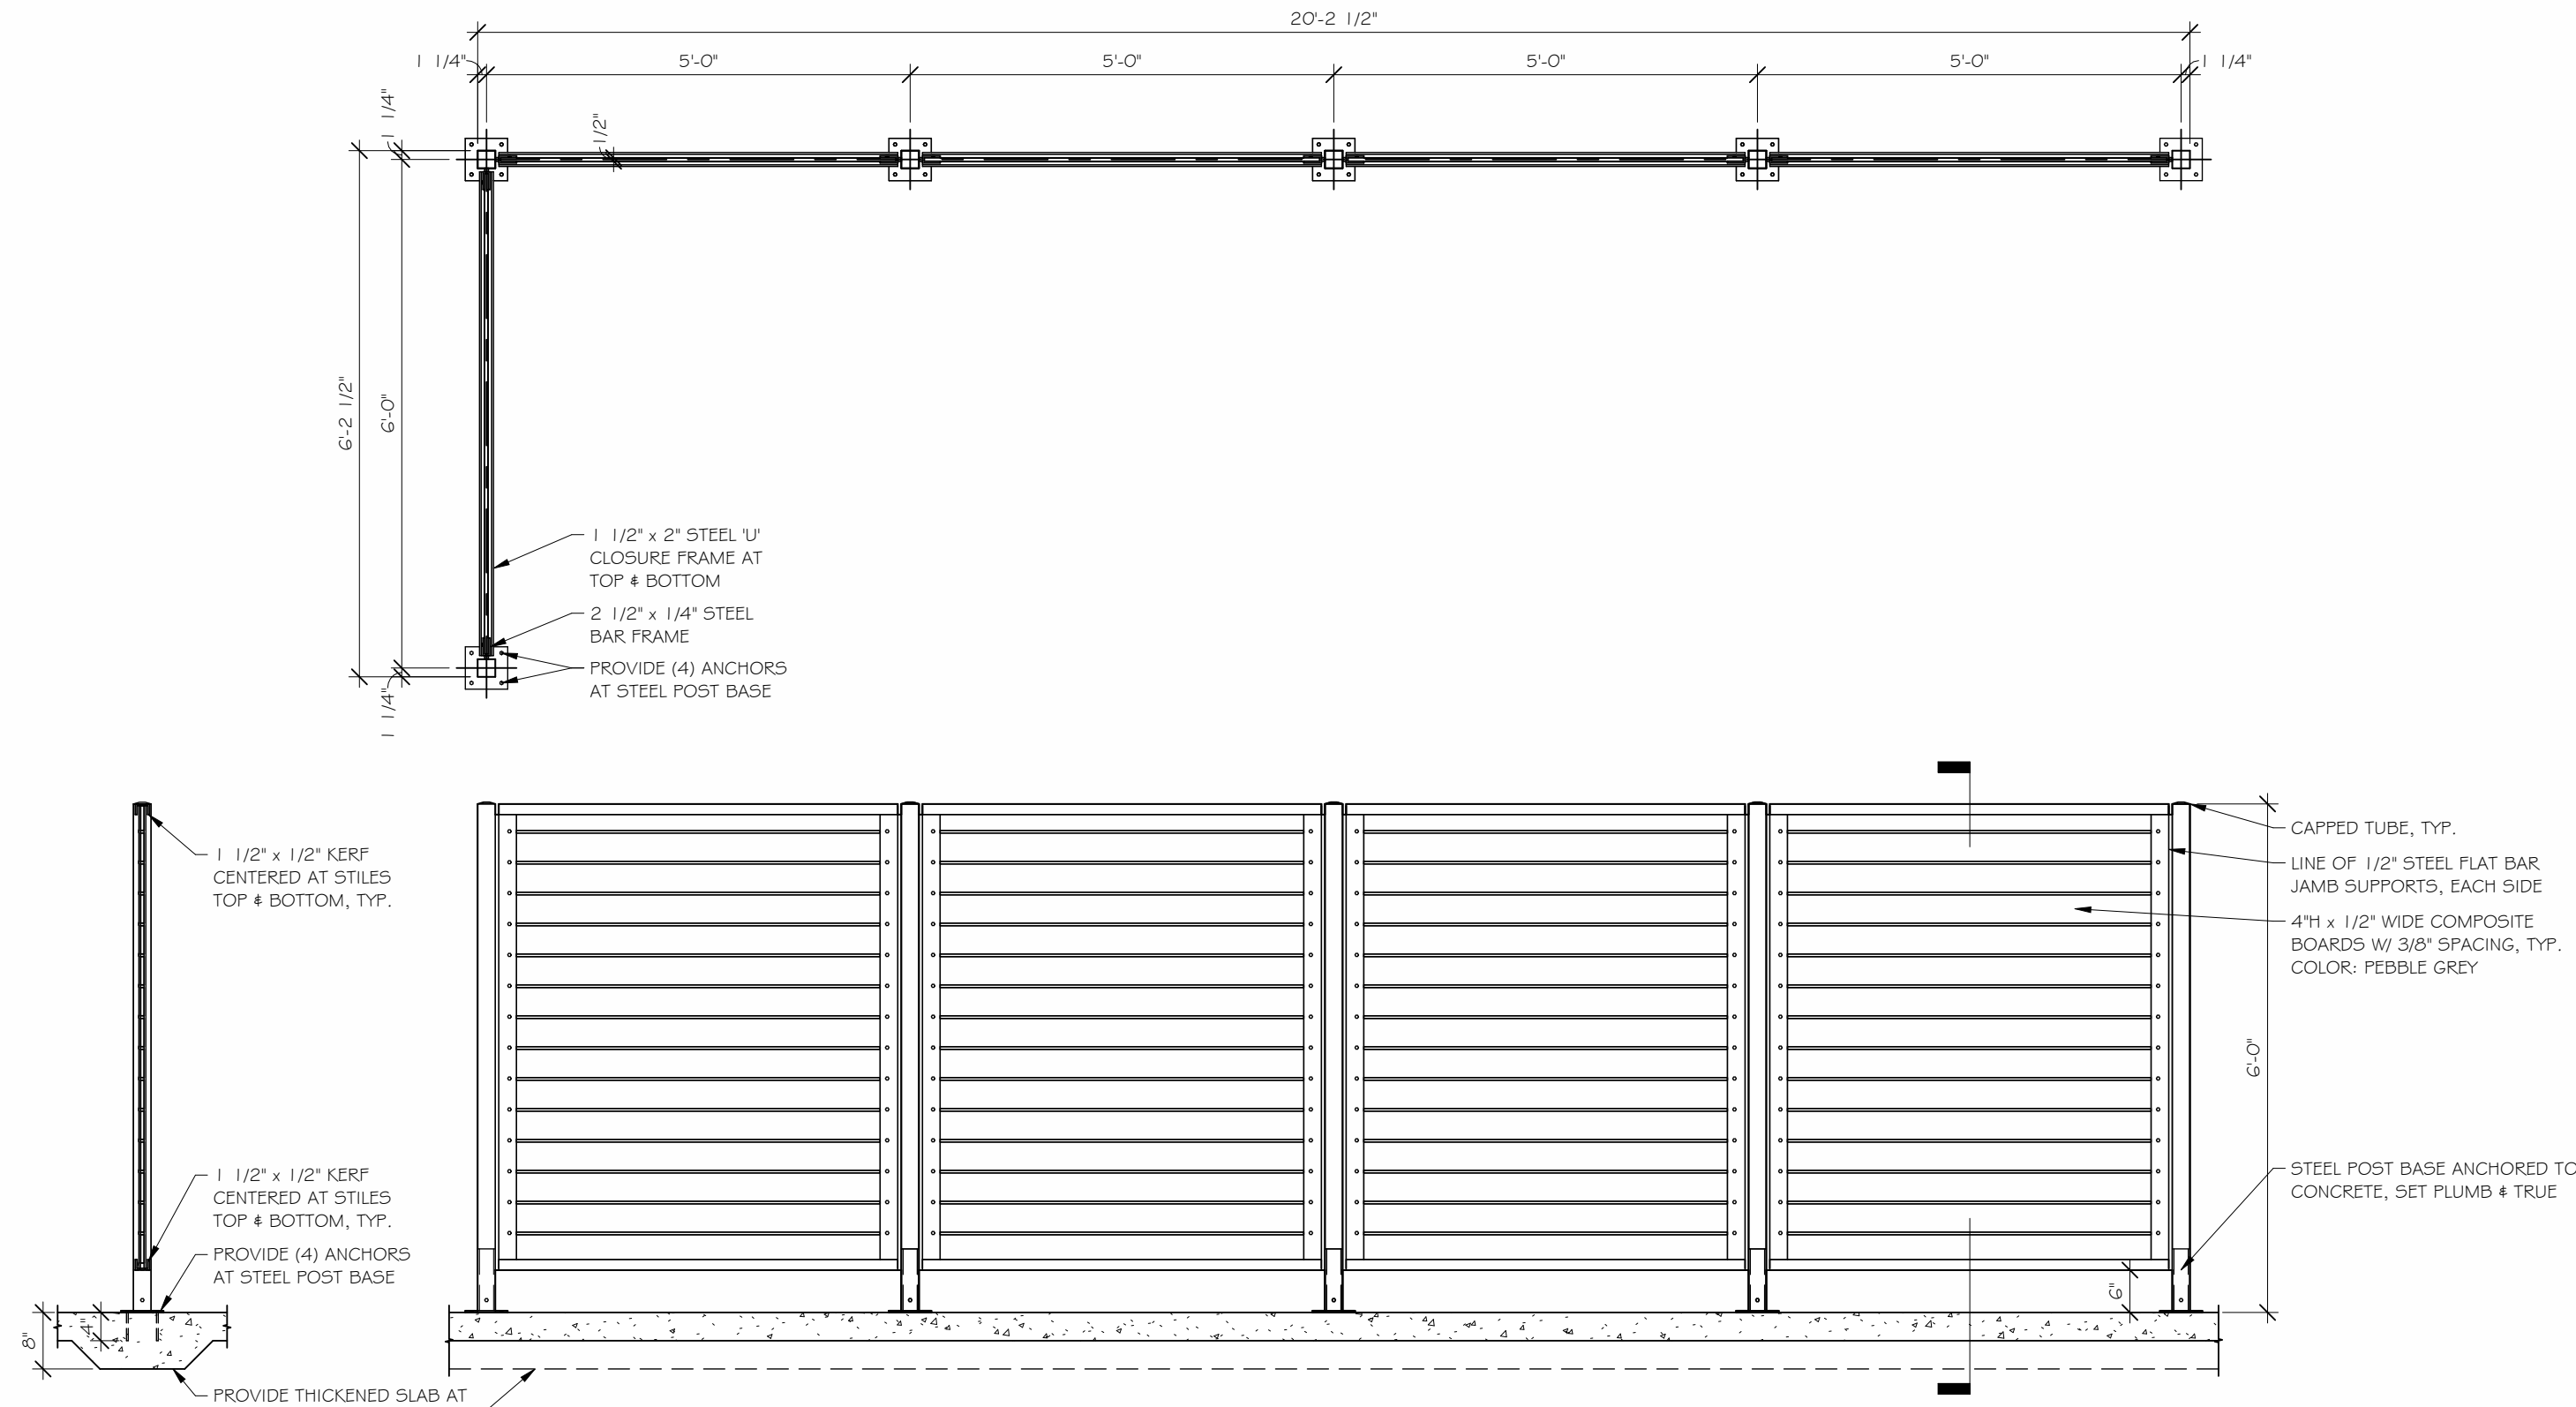

3 CART CORRAL DETAIL
1/2" = 1'-0"

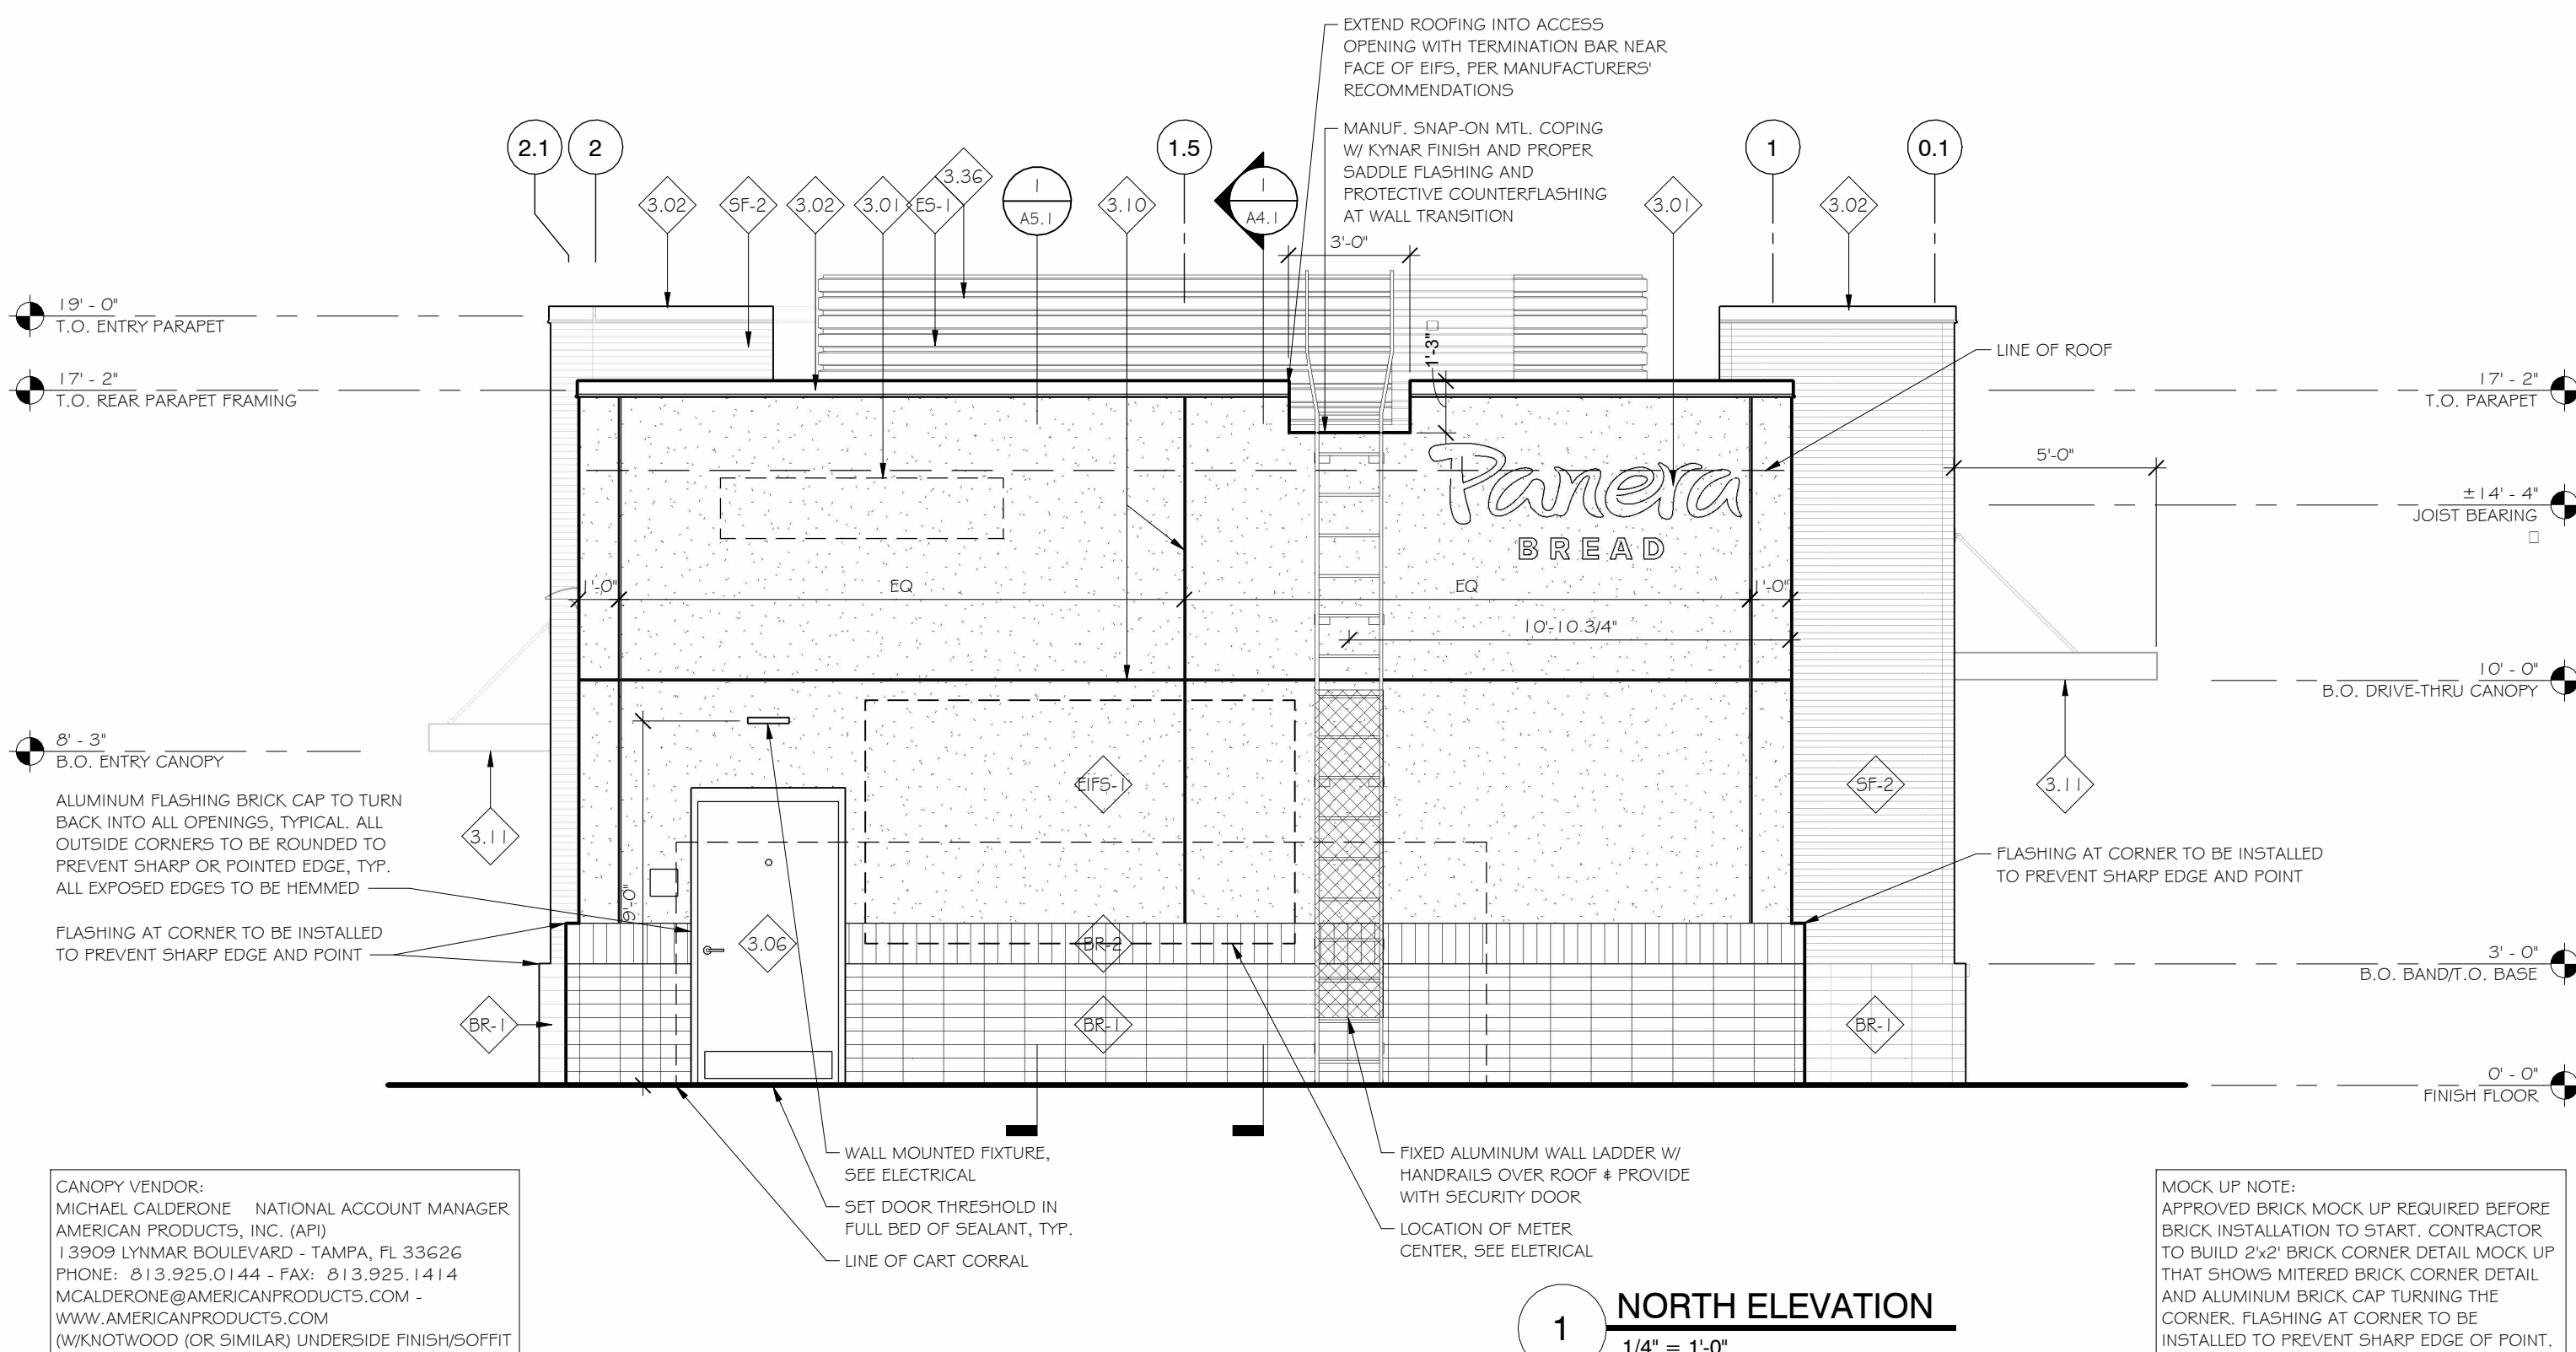

1 NORTH ELEVATION
1/4" = 1'-0"

REVISIONS:

DATE:
10/04/2024


PROJECT NUMBER:
2421

SHEET NAME:
EXTERIOR ELEVATIONS AND
DETAILS

SHEET NUMBER:

A3.2

FINISH LEGEND		
ROOM TAG F B W C - 00-000	FLOOR:	O - EXPOSED CONCRETE
	BASE:	O - NO BASE
	WALL:	O - GYPSUM BOARD BY TENANT
	CEILING:	O - CEILING BY TENANT

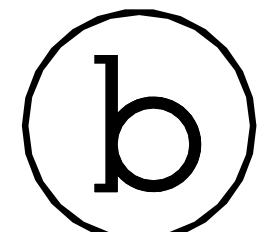

bDot Architecture, Inc.
P: 205.438.8053 | E: info@bdotinc.com
130.416 Street South, Suite 102 | Birmingham, AL 35222

PRELIMINARY
DRAWINGS
NOT FOR
CONSTRUCTION

©2024 bDot Architecture, Inc.
Drawings, design concepts, and written materials shall not be used or reproduced in whole or part in any form or format without prior written consent of bDot Architecture, Inc.

All discrepancies in the construction drawings and / or specifications not brought to the architect's attention during the bid or pricing phase of the project shall become subject to the interpretation of the architect during the construction process and will not be grounds for a change order of any kind.

PANERA BREAD
SHELL BUILDING PACKAGE
BRYANT, ARKANSAS

REVISIONS:


DATE:
10/04/2024


PROJECT NUMBER:
2421

SHEET NAME:
FLOOR PLAN

SHEET NUMBER:

A1.1

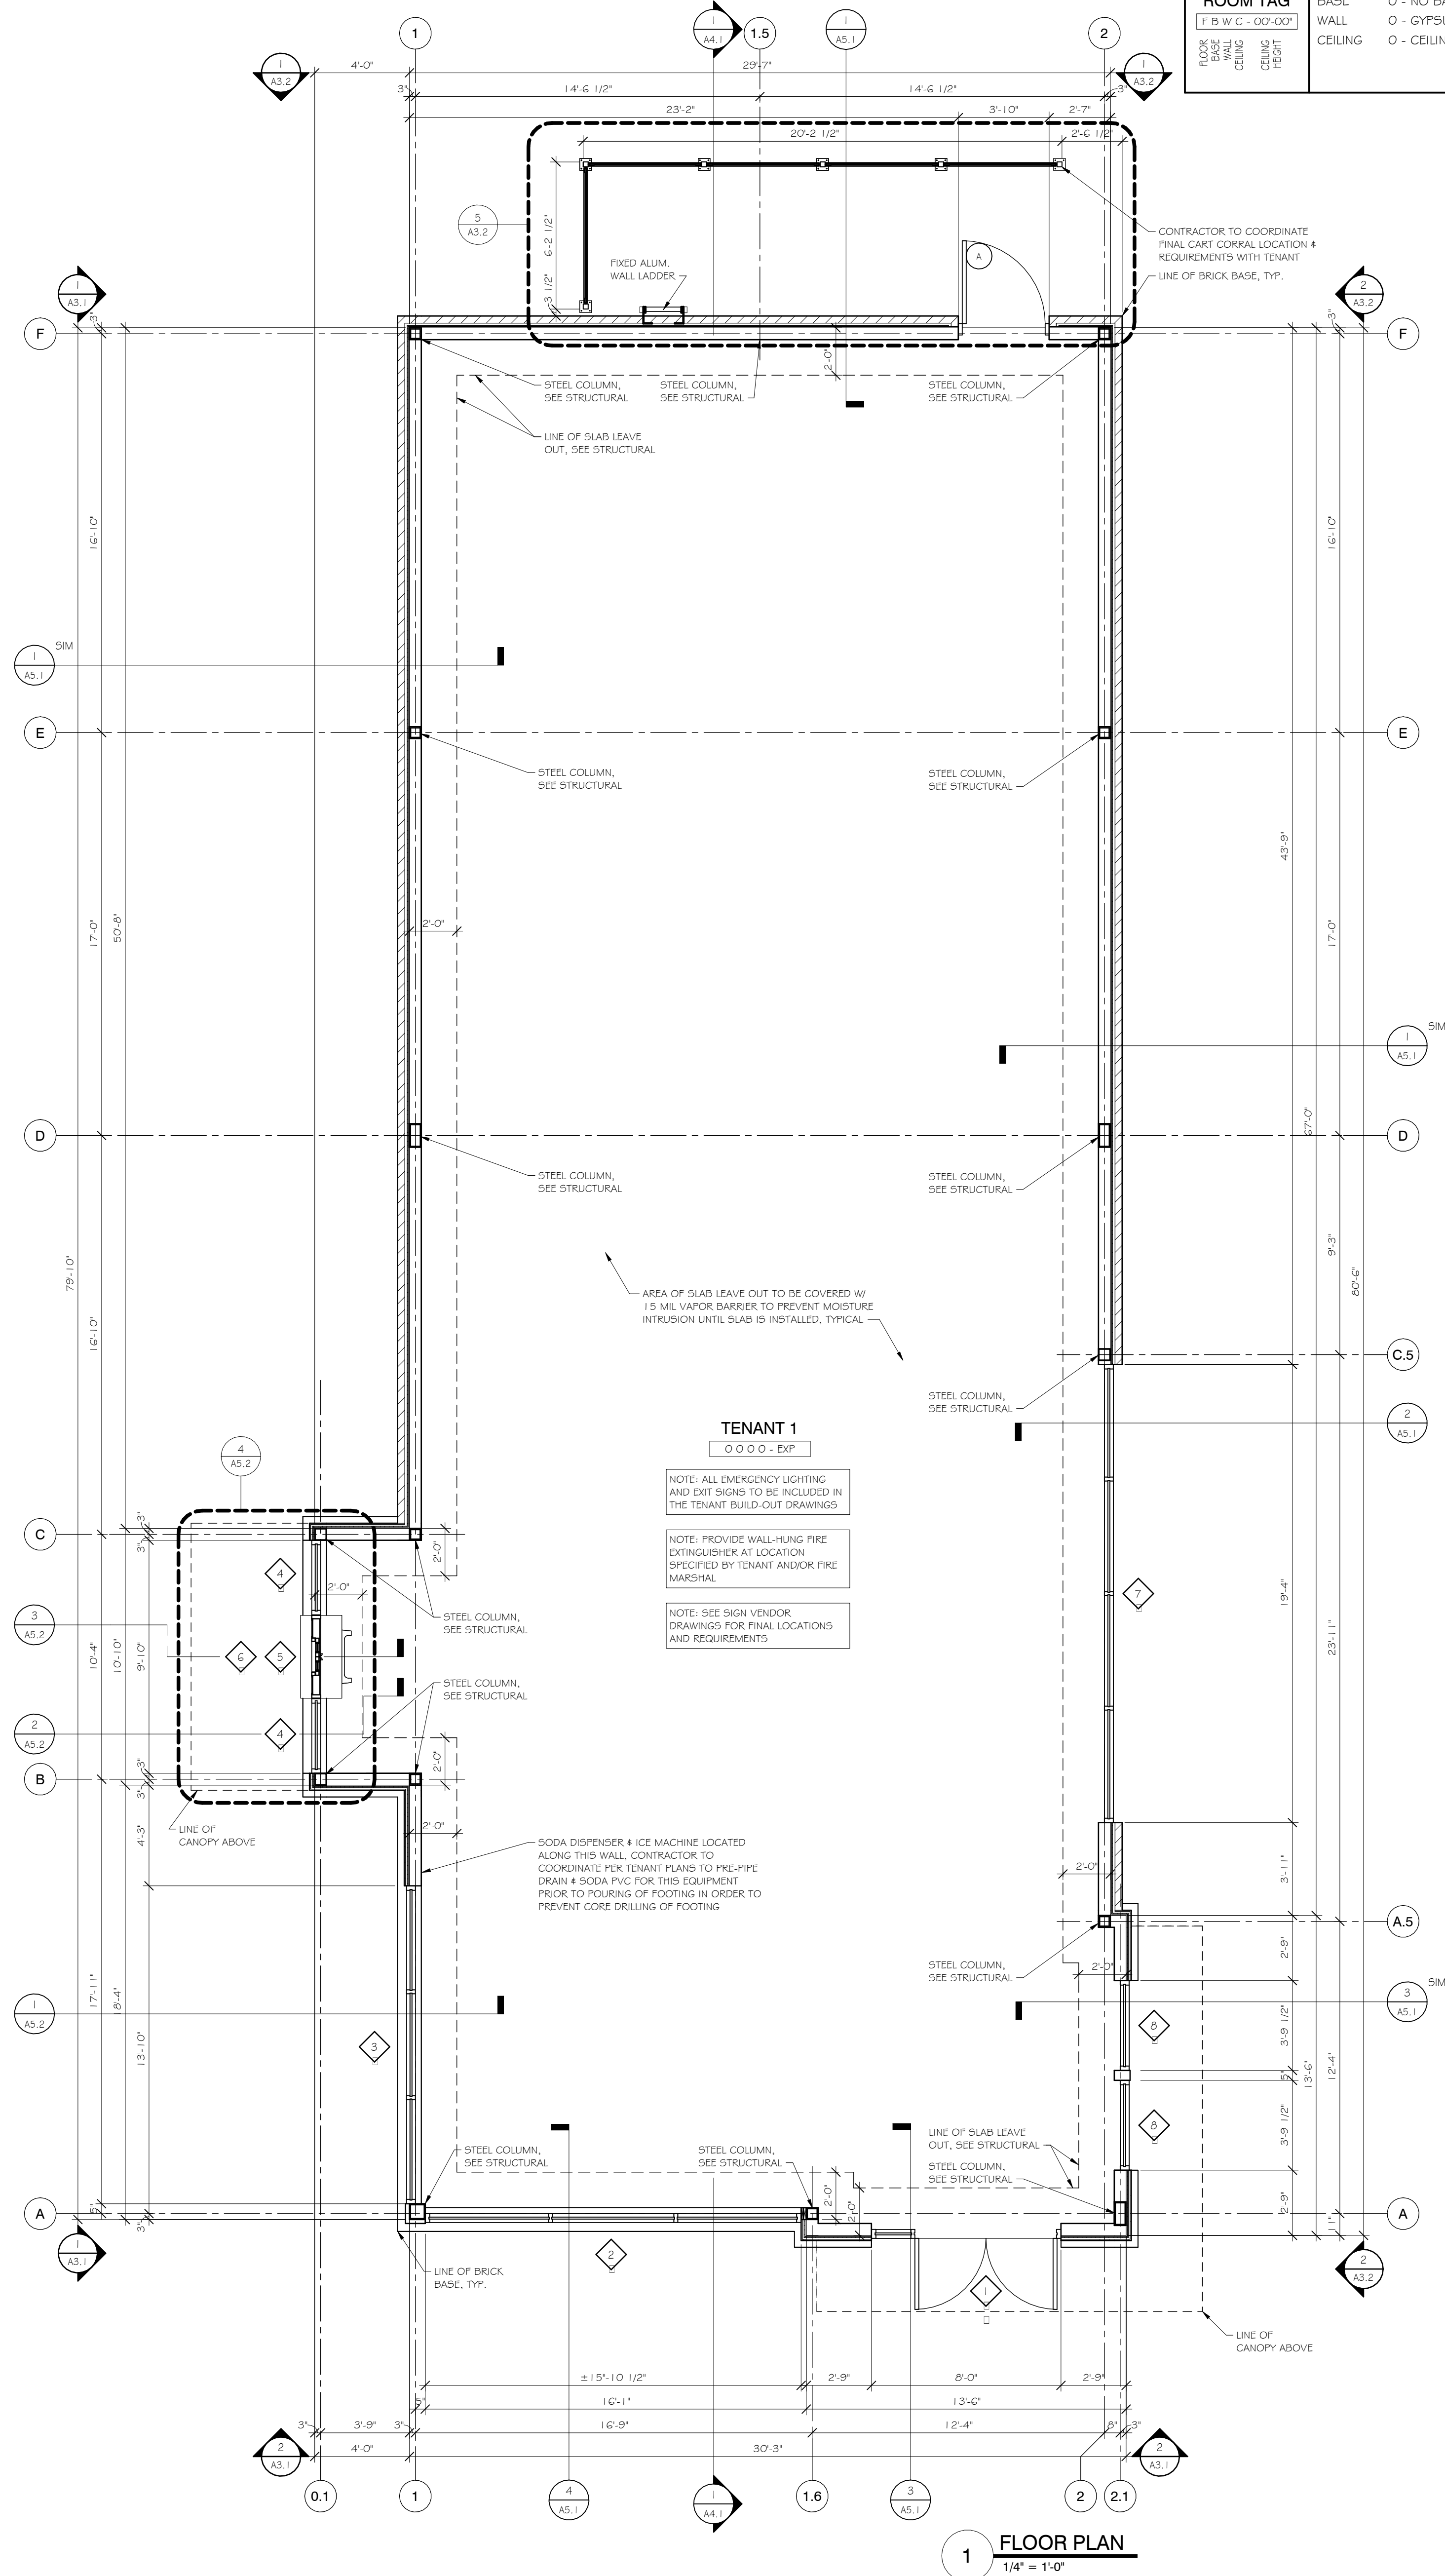

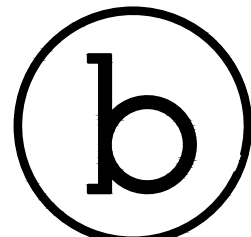

bDot Architecture, Inc.
P: 205.458.8025 | E: info@b-dot.com
130 4th South, Suite 102 | Birmingham, AL 35222

© 2024 bDot Architecture, Inc.
Drawings, design concepts, and written materials shall not be used or reproduced in whole or part in any form or format without prior written consent of bDot Architecture, Inc.

All discrepancies in the construction drawings and / or specifications not brought to the architect's attention during the bid or pricing phase of the project shall become subject to the interpretation of the architect during the construction process and will not be grounds for a change order of any kind.

PANERA BREAD
SHELL BUILDING PACKAGE

REVISIONS:

DATE:
1/3/2025

PROJECT NUMBER:
2421

SHEET NAME:
ELECTRICAL DETAILS
AND SCHEDULES


SHEET NUMBER:

E0.2

LIGHTING FIXTURE SCHEDULE									
MARK	MANUFACTURER	CATALOG NUMBER	VOLTAGE	LAMPS			MOUNTING HEIGHT	MOUNTING TYPE	REMARKS
				WATTS	LUMENS	TYPE			
A	COOPER	GLEON-SA6C-5MQ	120	333	44,441	LED MATCH EXISTING	MOUNT 30' SQUARE STRAIGHT STEEL POLE - MATCH EXISTING - SEE DETAIL "E-LP1"		FSA ME
C	LIGHTOLIER	FD-6R-4CCT-FD-6NCP	120	13.5	900	LED 3,000K	CEILING	RECESSED (CANOPY)	
CE	LIGHTOLIER	FD-6R-4CCT-FD-6NCP WITH REMOTE 20W EMERGENCY INVERTER OR BATTERY PACK	120	13.5	900	LED 3,000K	CEILING	RECESSED (CANOPY)	EM
WE	LITHONIA OR EQUAL	ARC1-LED-P2-E4WH	120	17	2,100	LED MATCH EXISTING	ABOVE DOOR	OUTLET BOX	EM FSA
W2	LITHONIA OR EQUAL	DSXW1-LED-P4-T3M-HS	120	29	3,880	LED MATCH EXISTING	12'-0" A.F.F.	OUTLET BOX	FSA
W3	LITHONIA OR EQUAL	DSXW1-LED-P4-T4M-HS	120	29	3,957	LED MATCH EXISTING	12'-0" A.F.F.	OUTLET BOX	FSA

LIGHTING FIXTURE SCHEDULE GENERAL NOTES:
1. ALL FIXTURES AND BALLASTS/DRIVERS SHALL BE RATED FOR OPERATION IN AMBIENT TEMPERATURES UP TO 55 DEGREES CELSIUS.

LIGHTING FIXTURE SCHEDULE KEYED NOTES:
EM EMERGENCY FIXTURE. PROVIDE REMOTE MOUNT EMERGENCY LIGHTING INVERTER OR BATTERY INSTALLED IN ACCESSIBLE LOCATION.
FSA PROVIDE FINISH AS SELECTED BY ARCHITECT.
ME INTENT IS TO MATCH EXISTING FIXTURE COLOR/TEMPERATURE, OUTPUT, FINISH, POLE HEIGHT AND GENERAL APPEARANCE. FIELD-VERIFY SPECIFIED FIXTURES MATCH EXISTING OR VERIFY ACCEPTABILITY OF SELECTION WITH OWNER PRIOR TO ORDERING.

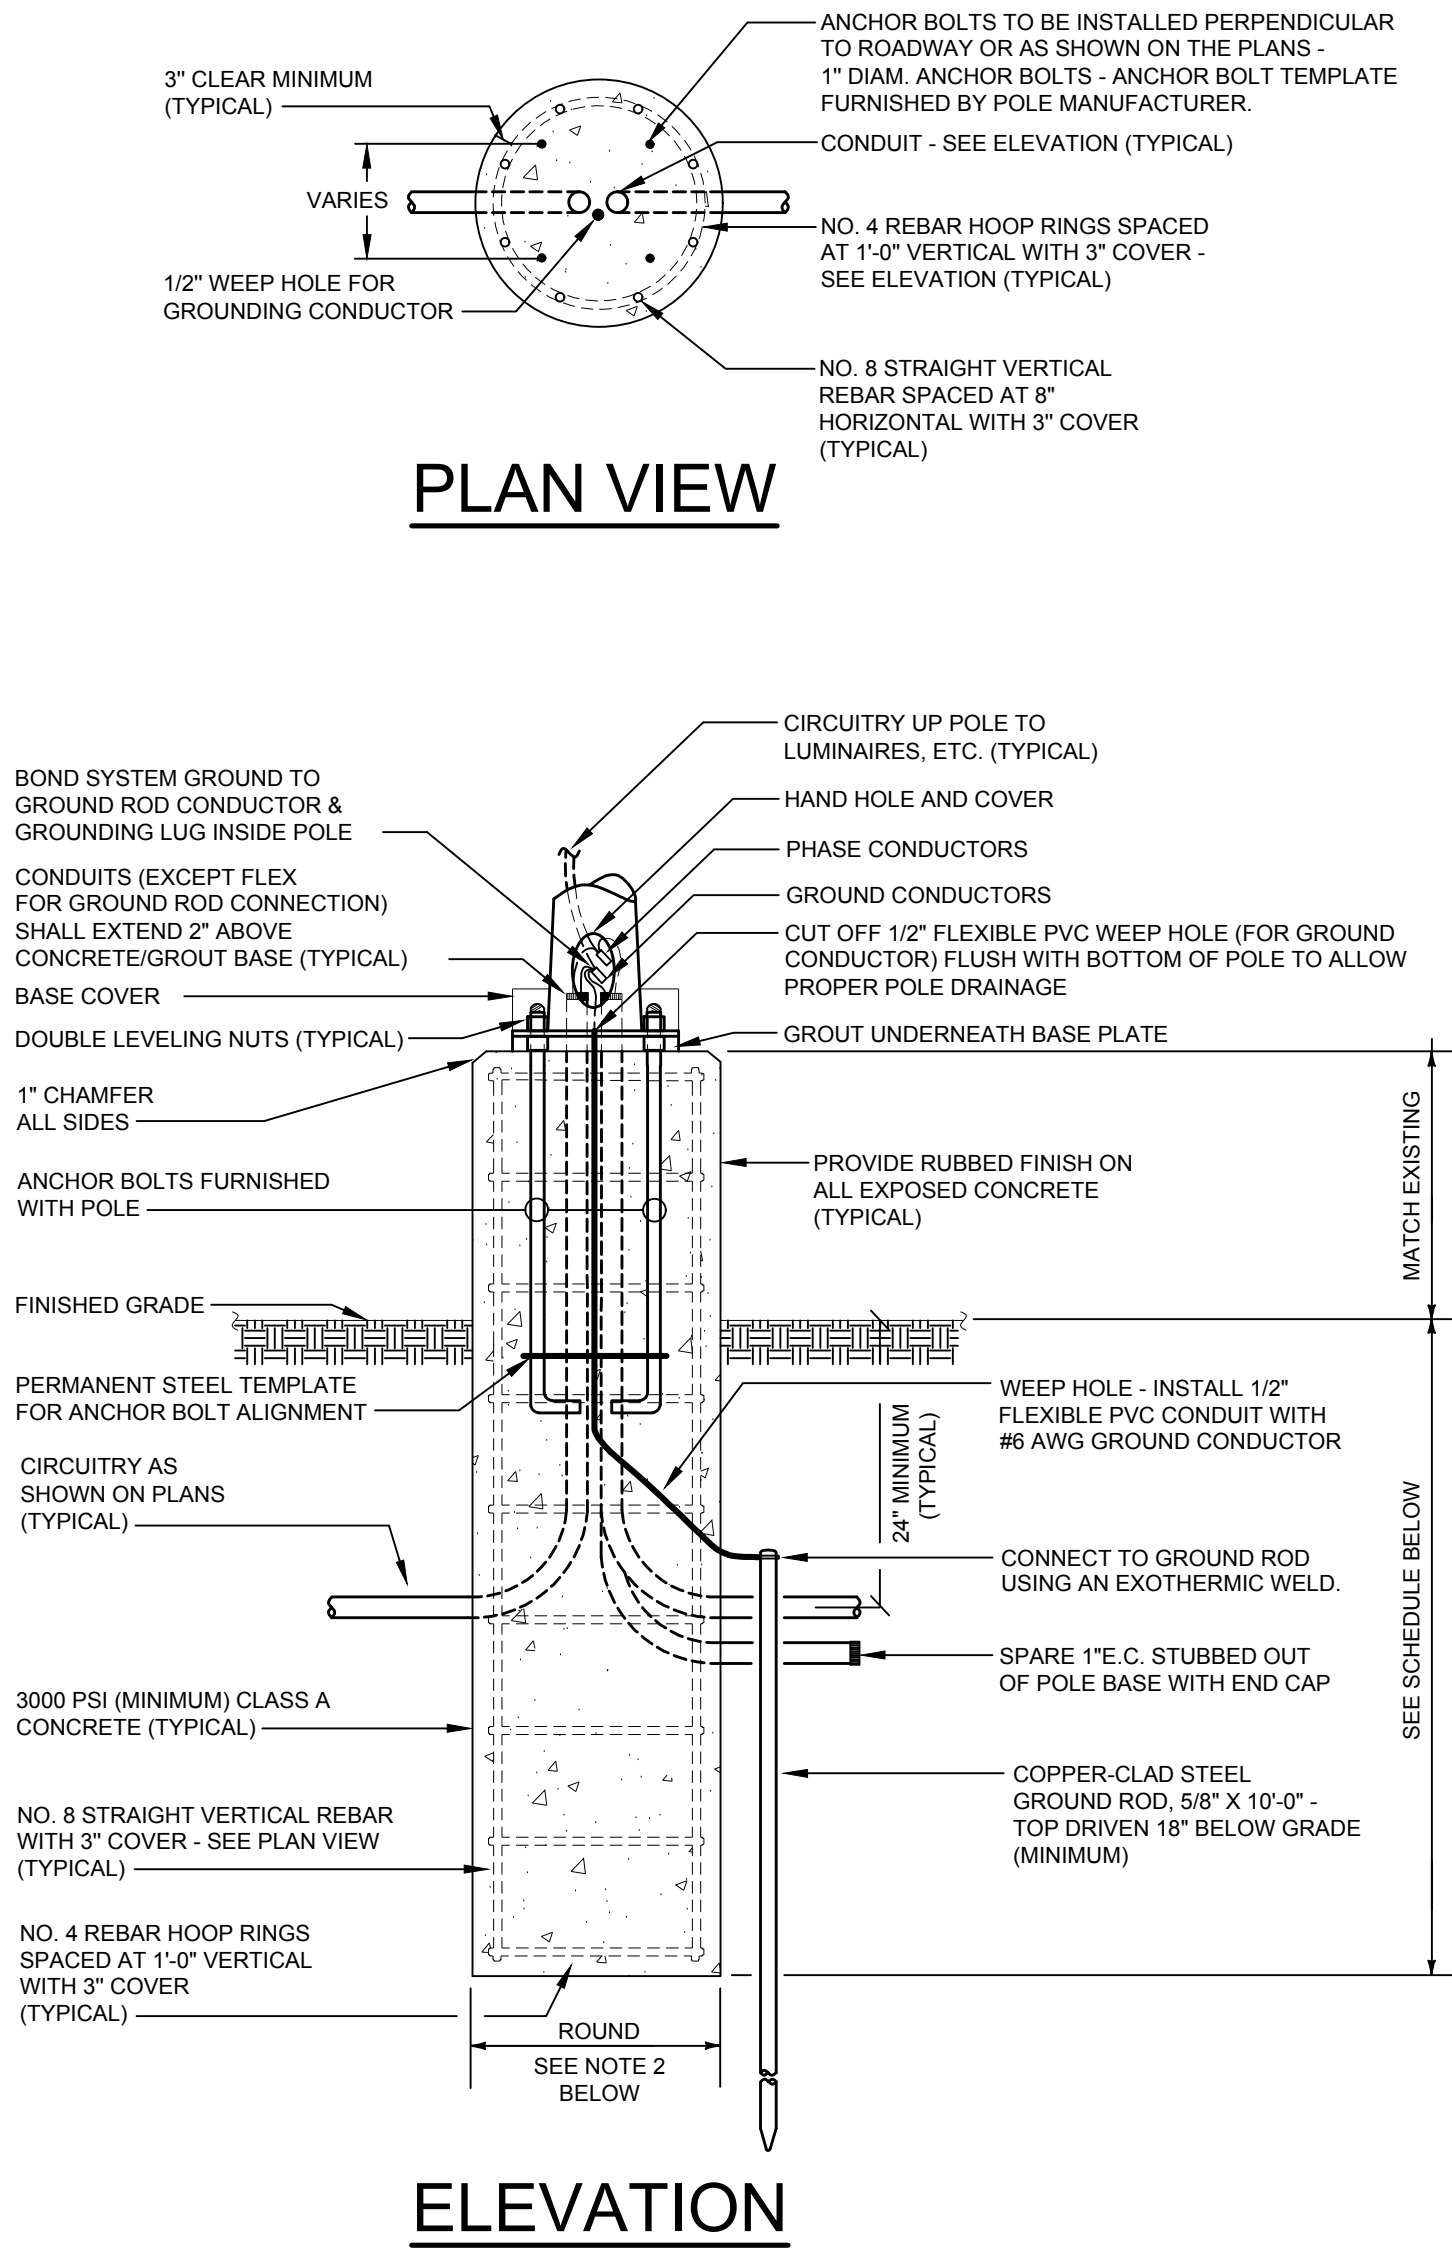


DETAIL "E-LP1" EXPOSED LIGHT POLE BASE

SCALE : NONE

DETAIL NOTES	
1. THIS CONTRACTOR SHALL CONFIRM SOIL CONDITIONS PRIOR TO BID OR INSTALLATION. IF SOIL CONDITIONS/TYPES ARE DIFFERENT THAN THE SPECIFIC TYPES INDICATED BELOW, OR THE POLE HEIGHTS ARE IN EXCESS OF THOSE LISTED BELOW, OR THE BASIC WIND SPEED FOR THE PROPOSED POLE LOCATION (PER ASCE 7 BASIC WIND SPEED MAPS) IS IN EXCESS OF 100MP, OR THE COMBINED E.P.A. OF ALL LUMINAIRES/ACCESSORIES INSTALLED ON A POLE IS IN EXCESS OF 5.5 S.F., THE CONTRACTOR SHALL RETAIN A QUALIFIED STRUCTURAL ENGINEER (LICENSED IN THE STATE OF THE PROJECT) TO PROVIDE A PROJECT-SPECIFIC STRUCTURAL DESIGN FOR THE PROPOSED POLE BASE(S), AND SHALL INCLUDE ALL COSTS (FOR THE DESIGN AND THE REQUIRED POLE BASES) IN THE BID.	
2. MINIMUM POLE BASE DIAMETER SHALL BE THE GREATER OF THE FOLLOWING: A. ANCHOR BOLT CIRCLE DIAMETER PLUS 6" (TO PROVIDE MINIMUM 4" COVER OVER ALL ANCHOR BOLTS). B. 20" DIAMETER. C. DIAMETER AS REQUIRED BY SOIL CONDITIONS OR BY POLE SUPPLIER.	
3. CONTRACTOR SHALL VERIFY LOCATIONS OF ALL UNDERGROUND UTILITIES OR OBSTRUCTIONS TO AVOID CONFLICTS PRIOR TO INSTALLATION OF LIGHT POLE BASE(S).	
4. POLE SHALL BE RATED TO WITHSTAND THE WIND SPEED SPECIFIED FOR THE SPECIFIC PROJECT SITE LOCATION PER LATEST VERSION OF ASCE 7 BASIC WIND SPEED MAPS OR APPLICABLE LOCAL BUILDING CODE REQUIREMENTS (WHICHEVER IS MORE STRINGENT), WITH 1.3 GUST FACTOR WITH ALL LUMINAIRES & ACCESSORIES INSTALLED.	

POLE BASE DIMENSIONS				
POLE HEIGHT	MINIMUM BASE DEPTH (BELOW GRADE) (SEE NOTE 1 ABOVE)			BASE DIAMETER
	CLAYEY SOILS (CL, ML, CH, MH)	SANDY SOILS (SW, SP, SM, SC, GM, GC)	GRAVELLY SOILS (GW, GP)	
0 - 15 FT.	6'-0"	5'-0"	4'-6"	SEE NOTE 2 ABOVE
16 - 20 FT.	7'-0"	6'-0"	5'-0"	SEE NOTE 2 ABOVE
21 - 25 FT.	8'-0"	6'-0"	5'-6"	SEE NOTE 2 ABOVE
26 - 30 FT.	8'-6"	7'-0"	6'-0"	SEE NOTE 2 ABOVE
31 - 35 FT.	9'-0"	7'-6"	7'-0"	SEE NOTE 2 ABOVE
36 - 40 FT.	10'-0"	8'-0"	7'-6"	SEE NOTE 2 ABOVE
41 - 45 FT.	10'-6"	8'-6"	8'-0"	SEE NOTE 2 ABOVE
46 - 50 FT.	11'-0"	9'-0"	8'-6"	SEE NOTE 2 ABOVE

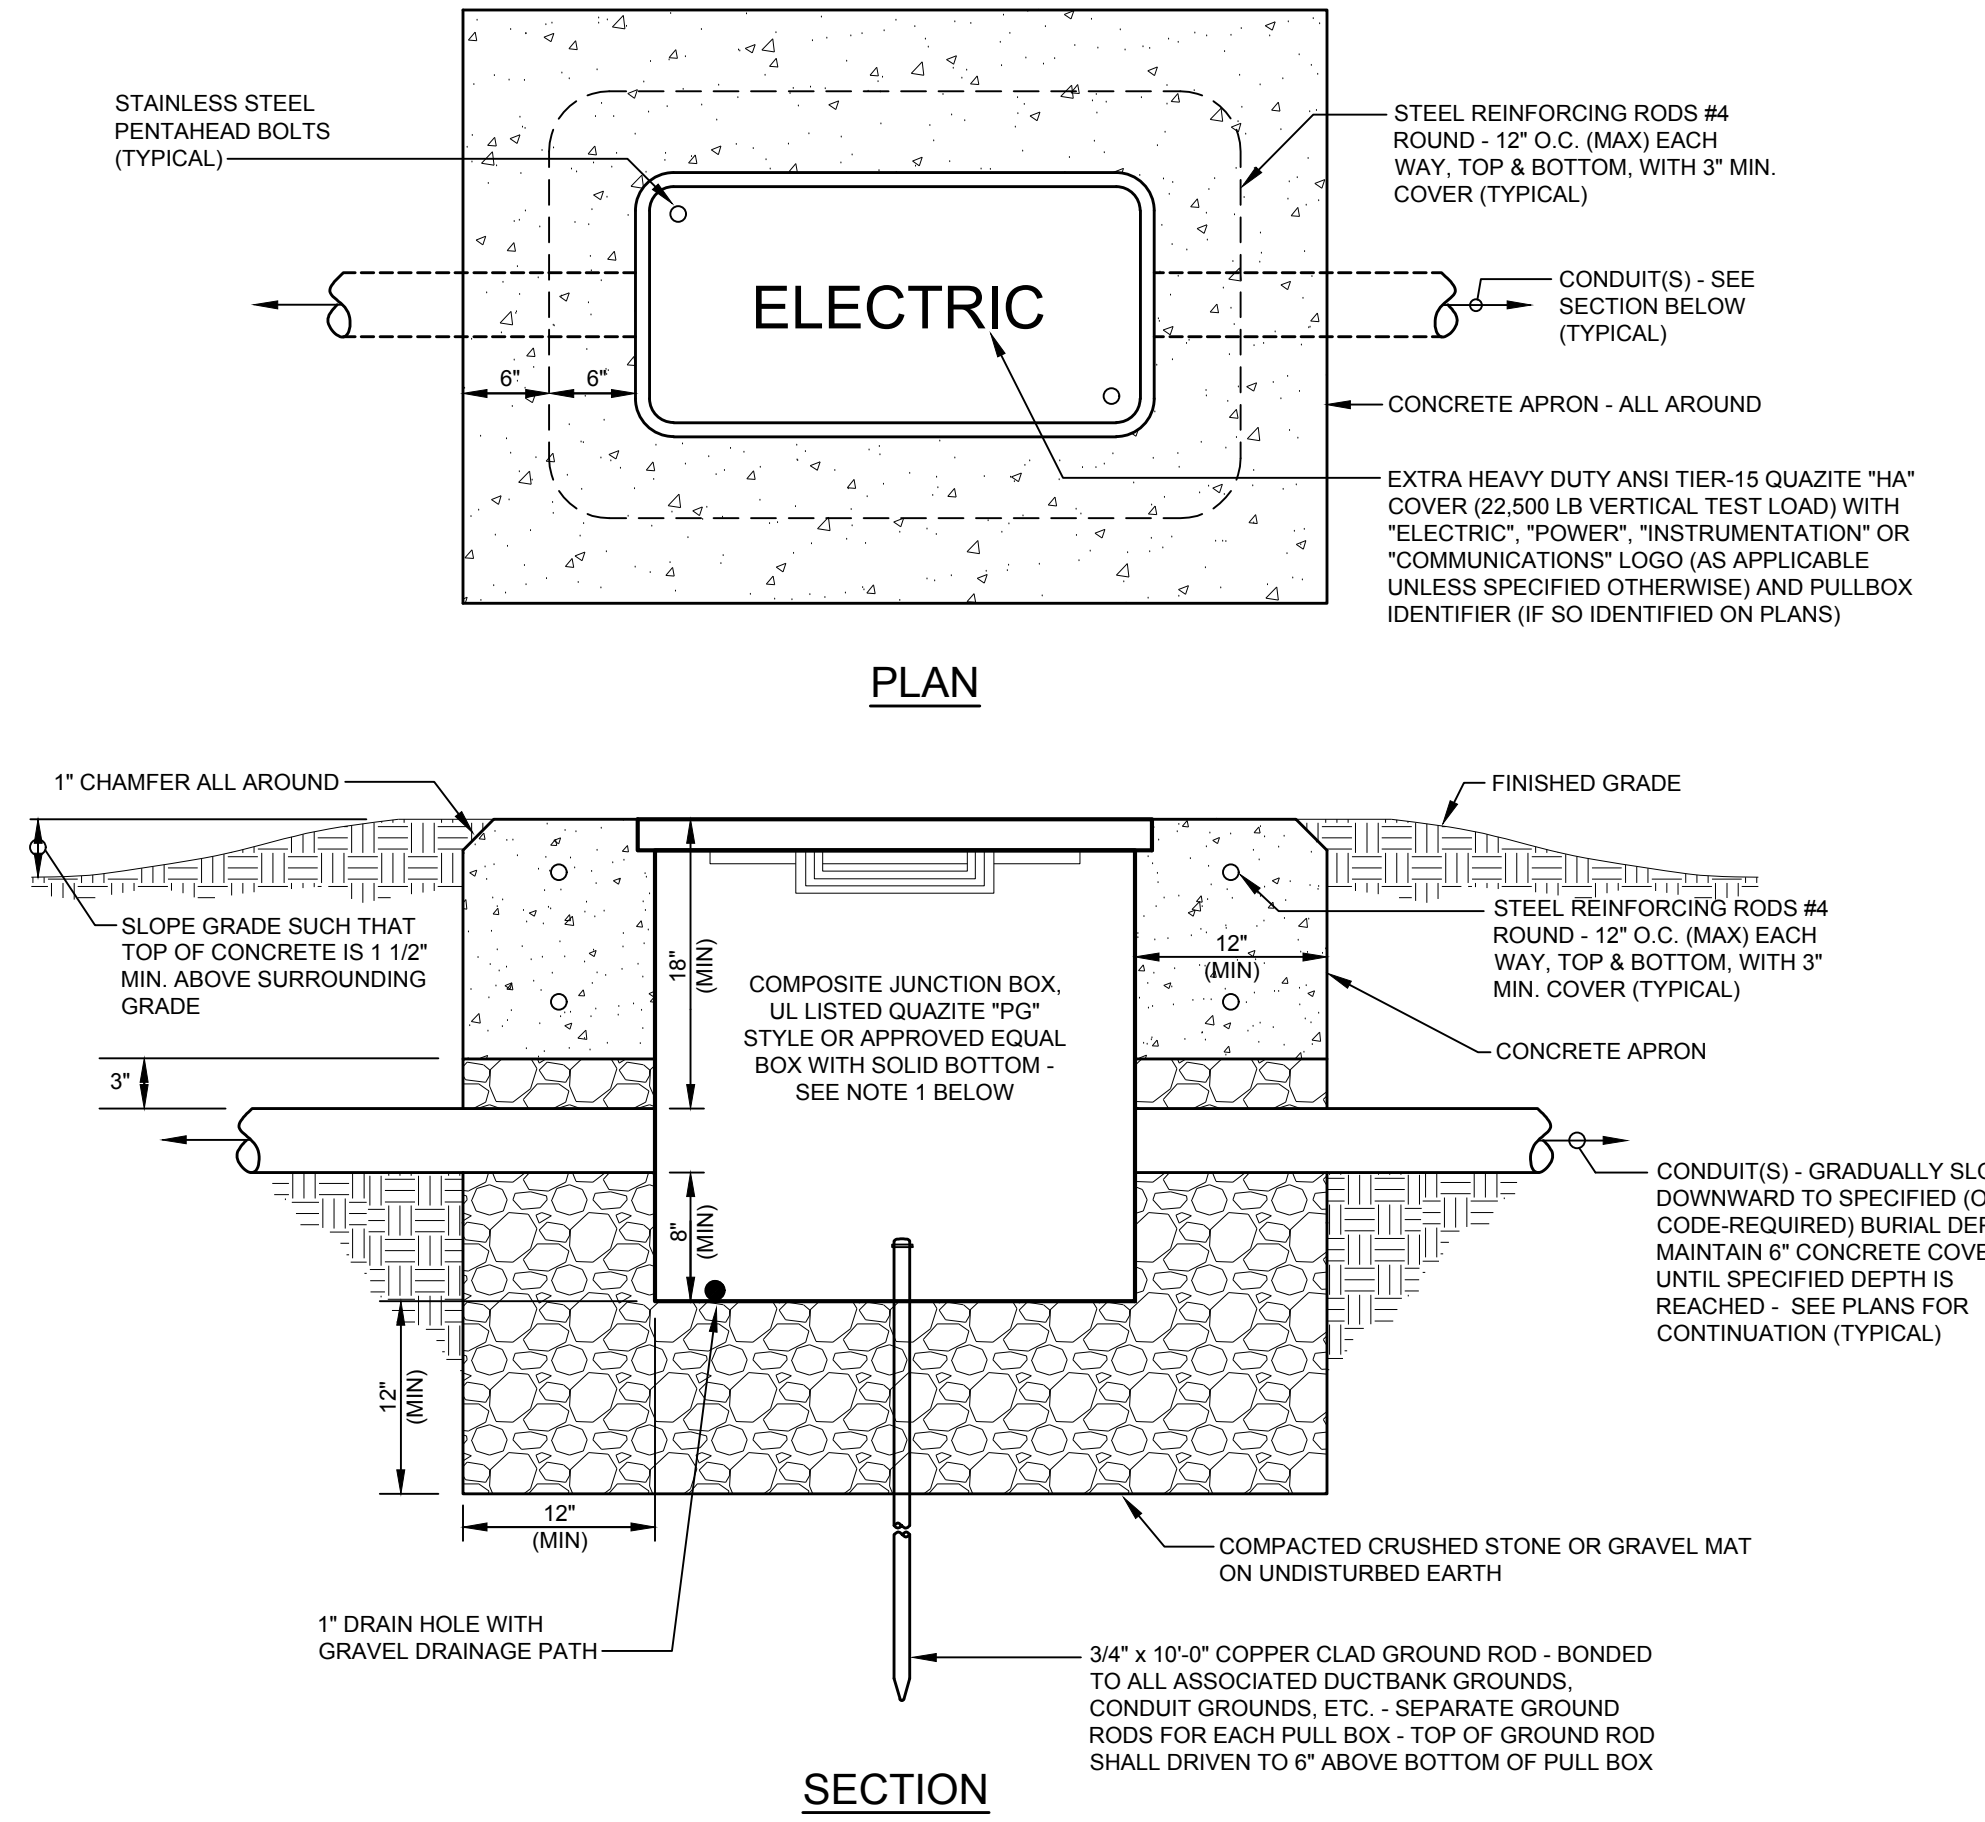

DETAIL "E-PBG2" BELOW-GRADE PULL BOX WITH CONCRETE APRON


SCALE : NONE

DETAIL NOTES	
1. MINIMUM PULL BOX INTERIOR DIMENSIONS SHALL BE 30"L X 17"W X 30"D OR AS REQUIRED TO ACCOMMODATE NUMBER OF CONDUITS AND WIRING. WHERE STACKED CONDUITS ENTER PULL BOX, ADJUST PULL BOX DEPTH AS REQUIRED TO PROVIDE THE SPECIFIED MINIMUM CLEARANCES. STACKED OR EXTENDED PULL BOXES ARE ACCEPTABLE (WHERE REQUIRED FOR INCREASED DEPTH).	
2. PROVIDE MINIMUM 3' SLACK CABLE LOOP FOR EACH CABLE WITHIN PULL BOX.	
3. COLOR CODE, TAG AND IDENTIFY ALL CABLES WITHIN PULL BOX.	
4. EACH BELOW-GRADE PULL BOX SHALL BE LOCATED IN AN AREA NOT NORMALLY SUBJECT TO VEHICULAR TRAFFIC. EXACT LOCATION OF EACH PULL BOX SHALL BE FIELD-COORDINATED BY CONTRACTOR WITH OTHER EQUIPMENT, PIPING, SITE CONDITIONS, ETC.	



JACKSON,
RENFRO
& ASSOCIATES, INC.
ELECTRICAL ENGINEERING & DESIGN

TIM COCKE, PE
tim@jra.com
(205) 536-7107
(205) 995-5078
JRA 008 NO. 224250
31 INVERNESS CENTER PARKY • SUITE 100 • BIRMINGHAM, AL 35242


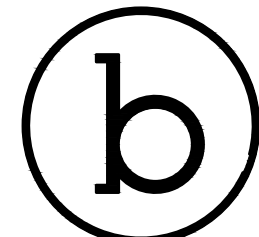


bDot Architecture, Inc.
P: 205.438.8025 | E: info@bdot.com
130 41st South, Suite 102 | Birmingham, AL 35222

©2024 bDot Architecture, Inc.
Drawings, design concepts, and written materials shall not be used or reproduced in whole or part in any form or format without prior written consent of bDot Architecture, Inc.

All discrepancies in the construction drawings and / or specifications not brought to the architect's attention during the bid or pricing phase of the project shall become subject to the interpretation of the architect during the construction process and will not be grounds for a change order of any kind.

PANERA BREAD
SHELL BUILDING PACKAGE

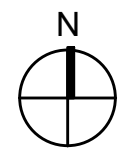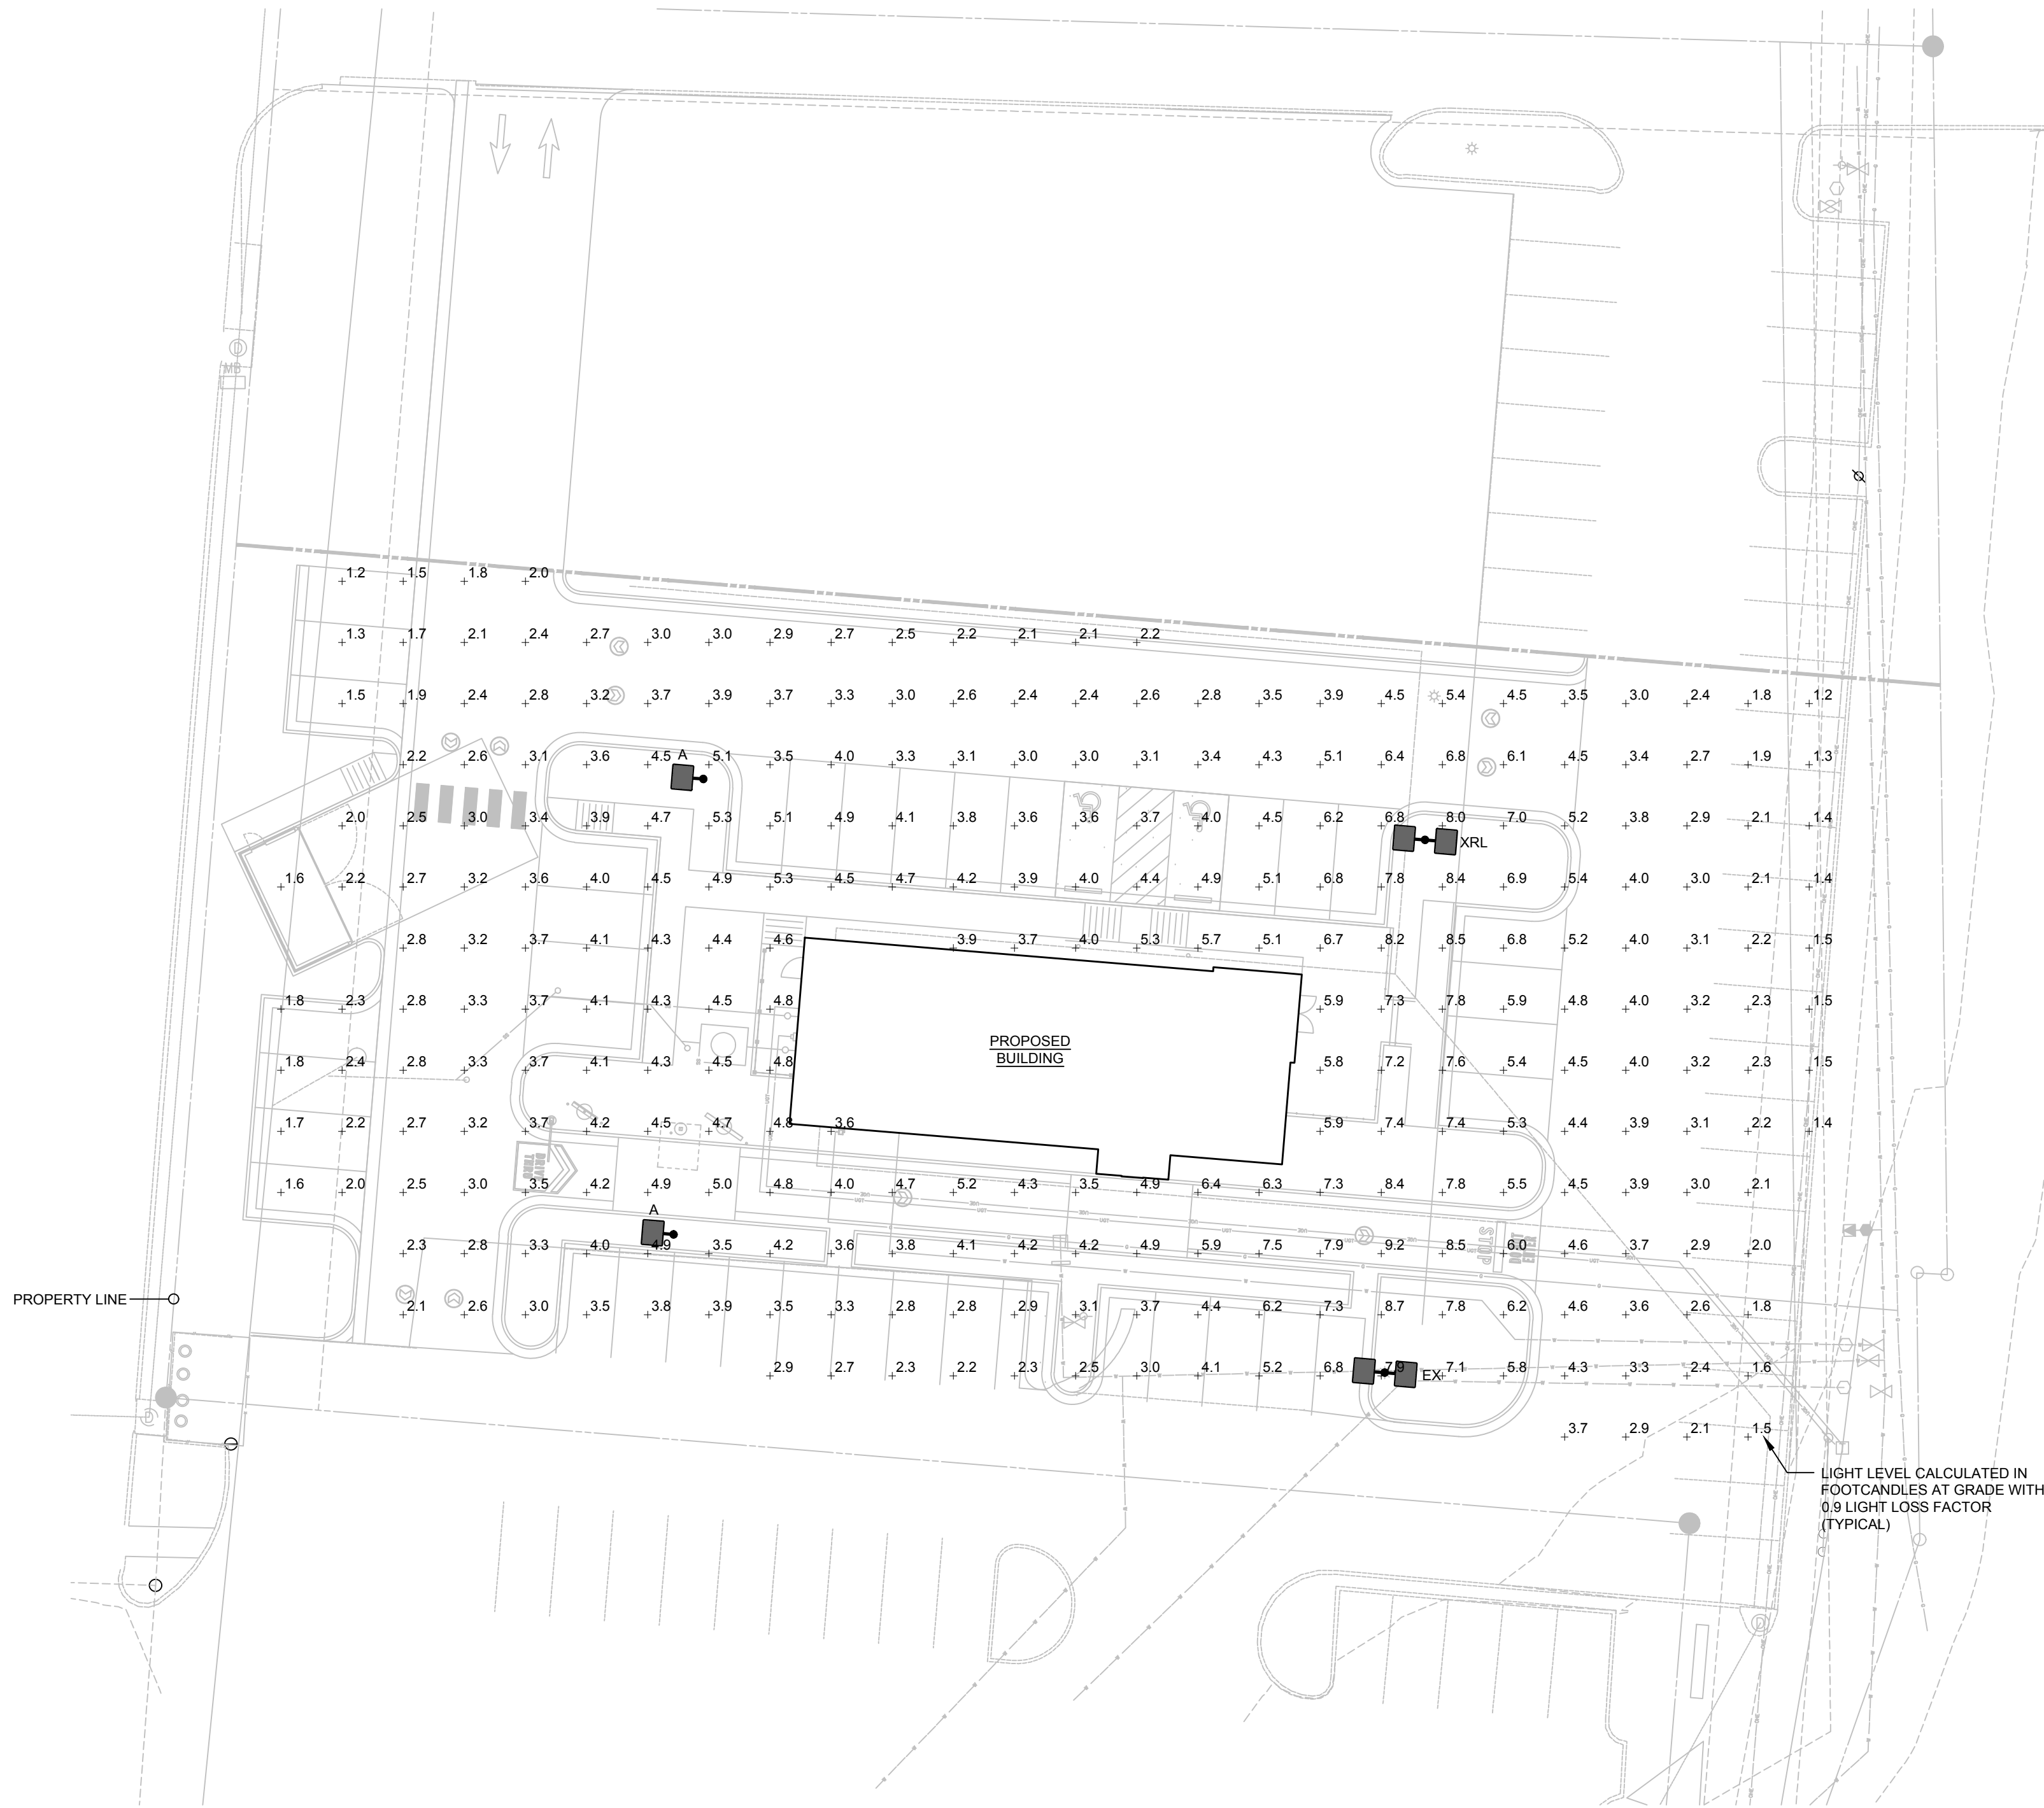

SITE PHOTOMETRIC PLAN
SCALE : 1" = 20'-0"

PHOTOMETRIC STATISTICS	
AVERAGE: 4.0 FC	MAXIMIN: 7.7.1
MAXIMUM: 9.2 FC	AVERAGEMIN: 3.3:1
MINIMUM: 1.2 FC	
APPLIES ONLY TO PARKING AREA, DRIVES AND LANDSCAPE AREA BETWEEN DRIVE AND BUILDING.	

REVISIONS:

DATE:
1/3/2025

PROJECT NUMBER:
2421

SHEET NAME :
SITE PHOTOMETRIC PLAN

SHEET NUMBER:

E1.1



JACKSON,
RENFRO
& ASSOCIATES, INC.
ELECTRICAL ENGINEERING & DESIGN
31 INVERNESS CENTER PARKWAY • SUITE 100 • BIRMINGHAM, AL 35242

TIM COOKE, PE
tim@jra.com
(205) 536-7107
(205) 995-3078
JRA ICB NO. 224250
ELECTRICAL ENGINEERING & DESIGN

Project		Catalog #		Type	
Prepared by		Notes		Date	



McGraw-Edison

GLEON Galleon

Area / Site Luminaire

Product Features



Product Certifications



Interactive Menu

- Ordering Information [page 2](#)
- Mounting Details [page 3](#)
- Optical Distributions [page 4](#)
- Product Specifications [page 4](#)
- Energy and Performance Data [page 4](#)
- Control Options [page 9](#)


Quick Facts

- Lumen packages range from 4,200 - 80,800 (34W - 640W)
- Efficacy up to 156 LPW
- Options to meet Buy American and other domestic preference requirements

Connected Systems

- WaveLinx PRO Wireless
- WaveLinx LITE Wireless
- Enlighted

Dimensional Details

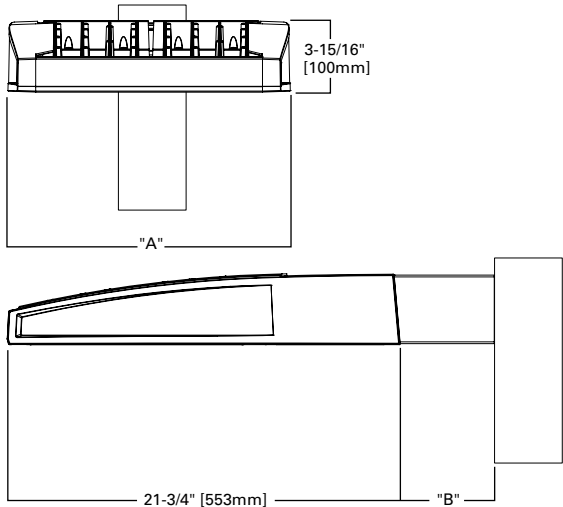

Number of Light Squares	"A" Width	"B" Standard Arm Length	"B" Extended Arm Length ¹	"B" QM Arm Length	"B" QML Length	"B" QMEA Length
1-4	15-1/2"	7"	10"	10-5/8"	--	16-9/16"
5-6	21-5/8"	7"	10"	10-5/8"	--	16-9/16"
7-8	27-5/8"	7"	13"	10-5/8"	10-5/16"	--
9-10	33-3/4"	7"	16"	--	10-5/16"	--

NOTES:
For arm selection requirements and additional line art, see Mounting Details section.

NOTES:
1. Visit <https://www.designlights.org/search/> to confirm qualification. Not all product variations are DLC qualified.
2. IDA Certified for 3000K CCT and warmer only.

Ordering Information


SAMPLE NUMBER: GLEON-SA4C-740-U-T4FT-GM

Product Family ^{1, 2}	Light Engine		Color Temperature	Voltage	Distribution	Mounting	Finish
	Configuration	Drive Current					
GLEON =Galleon BAA-GLEON =Galleon, Buy American Act Compliant ³⁴ TAA-GLEON =Galleon, Trade Agreements Act Compliant ³⁴	SA1 =1 Square SA2 =2 Squares SA3 =3 Squares SA4 =4 Squares SA5 =5 Squares ⁴ SA6 =6 Squares SA7 =7 Squares ⁵ SA8 =8 Squares ⁵ SA9 =9 Squares ⁶ SA0 =10 Squares ⁶	A =600mA B =800mA C =1000mA D =1200mA ¹⁵	722 =70CRI, 2200K 727 =70CRI, 2700K 730 =70CRI, 3000K 735 =70CRI, 3500K 740 =70CRI, 4000K 750 =70CRI, 5000K 760 =70CRI, 6000K 827 =80CRI, 2700K 830 =80CRI, 3000K AMB =Amber, 590nm ^{13, 15}	U =120-277V 1 =120V 2 =208V 3 =240V 4 =277V 8 =480V ^{7, 8} 9 =347V ⁷	T2 =Type II T2R =Type II Roadway T3 =Type III T3R =Type III Roadway T4FT =Type IV Forward Throw T4W =Type IV Wide 5NQ =Type V Narrow 5MQ =Type V Square Medium 5WQ =Type V Square Wide SL2 =Type II w/Spill Control SL3 =Type III w/Spill Control SL4 =Type IV w/Spill Control SLL =90° Spill Light Eliminator Left SLR =90° Spill Light Eliminator Right RW =Rectangular Wide Type I AFL =Automotive Frontline	[Blank] =Arm for Round or Square Pole EA =Extended Arm ⁹ MA =Mast Arm Adapter ¹⁰ WM =Wall Mount QM =Quick Mount Arm (Standard Length) ¹¹ QMEA =Quick Mount Arm (Extended Length) ¹² QML =Quick Mount Arm (Standard Length, Large) ³⁶	AP =Grey BZ =Bronze BK =Black DP =Dark Platinum GM =Graphite Metallic WH =White RALXX =Custom Color
Options (Add as Suffix)			Controls and Systems Options (Add as Suffix)			Accessories (Order Separately) ³⁵	
DIM =External 0-10V Dimming Leads ^{18, 19} F =Single Fuse (120, 277 or 347V Specify Voltage) FF =Double Fuse (208, 240 or 480V Specify Voltage) 20K =Series 20kV UL 1449 Surge Protective Device 2L =Two Circuits ^{16, 17} HA =50°C High Ambient HSS =Installed House Side Shield ²⁷ GRSBK =Glare Reducing Shield, Black ²² GRSWH =Glare Reducing Shield, White ²² LCF =Light Square Trim Painted to Match Housing ²⁶ MT =Installed Mesh Top TH =Tool-less Door Hardware CC =Coastal Construction finish ³ L90 =Optics Rotated 90° Left R90 =Optics Rotated 90° Right CE =CE Marking ²⁸ AHD145 =After Hours Dim, 5 Hours ²¹ AHD245 =After Hours Dim, 6 Hours ²¹ AHD255 =After Hours Dim, 7 Hours ²¹ AHD355 =After Hours Dim, 8 Hours ²¹ DALI =DALI Drivers			BPC =Button Type Photocontrol PR =NEMA 3-PIN Photocontrol Receptacle PR7 =NEMA 7-PIN Photocontrol Receptacle ²⁰ SPB2 =Dimming Occupancy Sensor with Bluetooth Interface, 8' - 20' Mounting ³³ SPB4 =Dimming Occupancy Sensor with Bluetooth Interface, 21' - 40' Mounting ³³ MS-L20 =Motion Sensor for ON/OFF Operation, 9' - 20' Mounting Height ²³ MS-L40W =Motion Sensor for ON/OFF Operation, 21' - 40' Mounting Height ²³ MS/X-L20 =Bi-Level Motion Sensor, 9' - 20' Mounting Height ^{23, 24} MS/X-L40W =Bi-Level Motion Sensor, 21' - 40' Mounting Height ^{23, 24} MS/DIM-L20 =Motion Sensor for Dimming Operation, 9' - 20' Mounting Height ²³ MS/DIM-L40W =Motion Sensor for Dimming Operation, 21' - 40' Mounting Height ²³ WLS2XX =WaveLinX LITE, SR Driver, Dimming Motion and Daylight, Bluetooth Programmable, 7' - 15' Mounting ³¹ WLS4XX =WaveLinX LITE, SR Driver, Dimming Motion and Daylight, Bluetooth Programmable, 15' - 40' Mounting ³¹ WPS2XX =WaveLinX PRO, SR Driver, Dimming Motion and Daylight, WAC Programmable, 7' - 15' Mounting ^{31,32} WPS4XX =WaveLinX PRO, SR Driver, Dimming Motion and Daylight, WAC Programmable, 15' - 40' Mounting ^{31,32} LWR-LW =Enlightened Sensor, 8'-16' Mounting Height ²⁵ LWR-LN =Enlightened Sensor, 16'-40' Mounting Height ²⁵ DIM10-L08 =AirMesh Occupancy Sensor (<8' Mounting) ¹⁸ DIM10-L20 =AirMesh Occupancy Sensor (9'-20' Mounting) ¹⁸ DIM10-L40 =AirMesh Occupancy Sensor (21'-40' Mounting) ¹⁸			OA/RA1013 =Photocontrol Shorting Cap MA1252 =10kV Surge Module Replacement MA1036-XX =Single Tenon Adapter for 2-3/8" O.D. Tenon MA1037-XX =2@180° Tenon Adapter for 2-3/8" O.D. Tenon MA1197-XX =3@120° Tenon Adapter for 2-3/8" O.D. Tenon MA1188-XX =4@90° Tenon Adapter for 2-3/8" O.D. Tenon MA1189-XX =2@90° Tenon Adapter for 2-3/8" O.D. Tenon MA1190-XX =3@90° Tenon Adapter for 2-3/8" O.D. Tenon MA1191-XX =2@120° Tenon Adapter for 2-3/8" O.D. Tenon MA1038-XX =Single Tenon Adapter for 3-1/2" O.D. Tenon MA1039-XX =2@180° Tenon Adapter for 3-1/2" O.D. Tenon MA1192-XX =3@120° Tenon Adapter for 3-1/2" O.D. Tenon MA1193-XX =4@90° Tenon Adapter for 3-1/2" O.D. Tenon MA1194-XX =2@90° Tenon Adapter for 3-1/2" O.D. Tenon MA1195-XX =3@90° Tenon Adapter for 3-1/2" O.D. Tenon FSIR-100 =Wireless Configuration Tool for Occupancy Sensor ²³ GLEON-MT1 =Field Installed Mesh Top for 1-4 Light Squares GLEON-MT2 =Field Installed Mesh Top for 5-6 Light Squares GLEON-MT3 =Field Installed Mesh Top for 7-8 Light Squares GLEON-MT4 =Field Installed Mesh Top for 9-10 Light Squares GLEON-QM =Quick Mount Arm Kit ¹¹ GLEON-QMEA =Quick Mount Extended Arm Kit ¹² LS/HSS =Field Installed House Side Shield ^{27, 29} LS/GRSBK-2PK =Glare Reducing Shield, Black ^{22, 29} LS/GRSWH-2PK =Glare Reducing Shield, White ^{22, 29} LS/PFS =Perimeter Shield, Black ¹⁴ WOLC-7P-10A =WaveLinX Outdoor Control Module ^{18, 30} TL7-HVG = AirMesh 7-PIN node, 110-480V ^{18, 30}	
NOTES: 1. Customer is responsible for engineering analysis to confirm pole and fixture compatibility for all applications. Refer to our white paper WP513001EN for additional support information. 2. DesignLights Consortium [®] Qualified. Refer to www.designlights.org Qualified Products List under Family Models for details. 3. Coastal construction finish salt spray tested to over 5,000-hours per ASTM B117, with a scribe rating of 9 per ASTM D1654. Not available with TH option. 4. Not compatible with MS/4-LXX or MS/1-LXX sensors. 5. Not compatible with extended quick mount arm (QMEA). 6. Not compatible with standard quick mount arm (QM) or extended quick mount arm (QMEA). 7. Requires the use of an internal step down transformer when combined with sensor options. Not available with sensor at 1200mA. Not available in combination with the HA high ambient and sensor options at 1A. 8. 480V must utilize Wye system only. Per NEC, not for use with ungrounded systems, impedance grounded systems or corner grounded systems (commonly known as Three Phase Three Wire Delta, Three Phase High Leg Delta and Three Phase Corner Grounded Delta systems.) 9. May be required when two or more luminaires are oriented on a 90° or 120° drilling pattern. Refer to arm mounting requirement table. 10. Factory installed. 11. Maximum 8 light squares. 12. Maximum 6 light squares. 13. Narrow-band 590nm +/- 5nm for wildlife and observatory use. Choose drive current A; supplied at 500mA drive current only. Available with 5WQ, 5MQ, SL2, SL3 and SL4 distributions. Can be used with HSS option. 14. Set of 4 pcs. One set required per Light Square. 15. Not available with HA option. 16. 2L is not available with MS, MS/X or MS/DIM at 347V or 480V. 2L in SA2 through SA4 requires a larger housing, normally used for SA5 or SA6. Extended arm option may be required when mounting two or more fixtures per pole at 90° or 120°. Refer to arm mounting requirement table. 17. Not available with Enlightened wireless sensors. 18. Cannot be used with other control options. 19. Low voltage control lead brought out 18" outside fixture. 20. Not available if any "MS" sensor is selected. Motion sensor has an integral photocell. 21. Requires the use of BPC photocontrol or the PR7 or PR photocontrol receptacle with photocontrol accessory. See After Hours Dim supplemental guide for additional information. 22. Not for use with T4FT, T4W or SL4 optics. See IES files for details. 23. The FSIR-100 configuration tool is required to adjust parameters including high and low modes, sensitivity, time delay, cutoff and more. Consult your lighting representative at Cooper Lighting Solutions for more information. 24. Replace X with number of Light Squares operating in low output mode. 25. Enlightened wireless sensors are factory installed only requiring network components LWP-EM-1, LWP-GW-1 and LWP-PoE8 in appropriate quantities. 26. Not available with house side shield (HSS). 27. Not for use with 5NQ, 5MQ, 5WQ or RW optics. A black trim plate is used when HSS is selected. 28. CE is not available with the LWR, MS, MS/X, MS/DIM, BPC, PR or PR7 options. Available in 120-277V only. 29. One required for each Light Square. 30. Requires PR7. 31. Replace XX with sensor color (WH, BZ or BK.) 32. WAC Gateway required to enable field-configurability: Order WAC-PoE and WPOE-120 (10V to PoE injector) power supply if needed. 33. Smart device with mobile application required to change system defaults. See controls section for details. 34. Only product configurations with these designated prefixes are built to be compliant with the Buy American Act of 1933 (BAA) or Trade Agreements Act of 1979 (TAA), respectively. Please refer to DOMESTIC PREFERENCES website for more information. Components shipped separately may be separately analyzed under domestic preference requirements. 35. For BAA or TAA requirements, Accessories sold separately will be separately analyzed under domestic preference requirements. Consult factory for further information. 36. Available for 7 - 10 squares.							

Mounting Details


Standard Arm (Drilling Pattern)

TYPE "N"

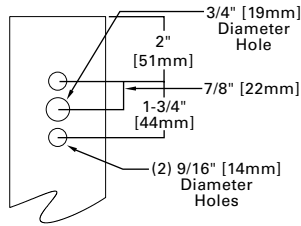


Quick Mount Arm


(Includes fixture adapter)

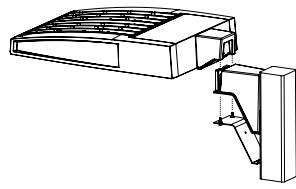


QM and QMEA Pole Mount (1 - 8 squares)

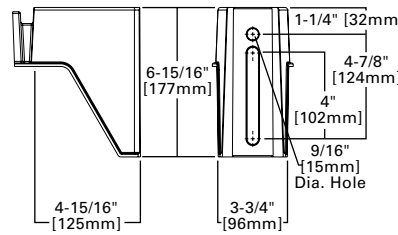


QML Pole Mount (7 - 10 squares)

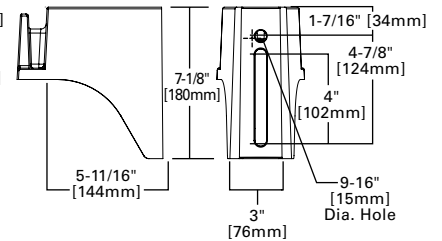


QM Quick Mount Arm (Standard, 1-8 squares)

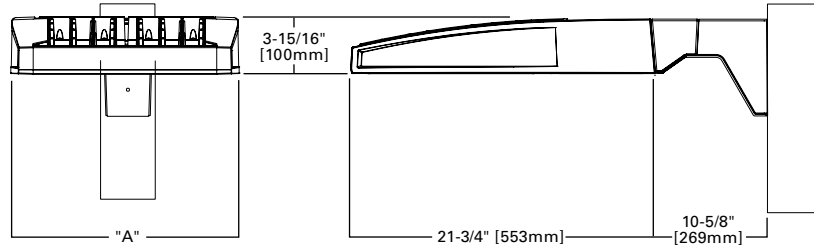


QMEA Quick Mount Arm (Extended, 1 - 6 squares)

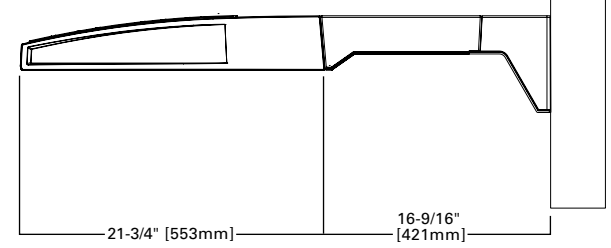

Standard Wall Mount

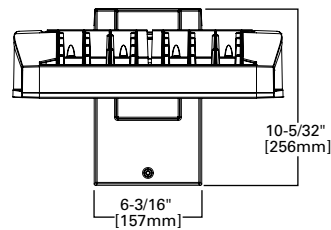


Mast Arm Mount

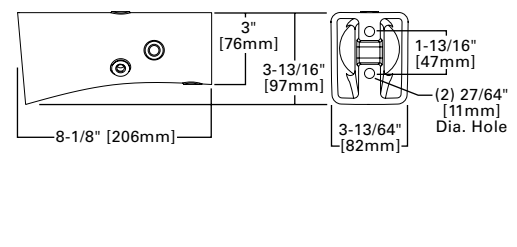

Arm Mounting Requirements

Number of Light Squares	Standard Arm @ 90° Apart	Standard Arm @ 120° Apart	Quick Mount Arm @ 90° Apart	Quick Mount Arm @ 120° Apart
1	Standard	Standard	QM Extended	Quick Mount
2	Standard	Standard	QM Extended	Quick Mount
3	Standard	Standard	QM Extended	Quick Mount
4	Standard	Standard	QM Extended	Quick Mount
5	Extended	Standard	QM Extended	Quick Mount
6	Extended	Standard	QM Extended	Quick Mount
7	Extended	Extended	--	Quick Mount
8	Extended	Extended	--	Quick Mount
9	Extended	Extended	--	--
10	Extended	Extended	--	--

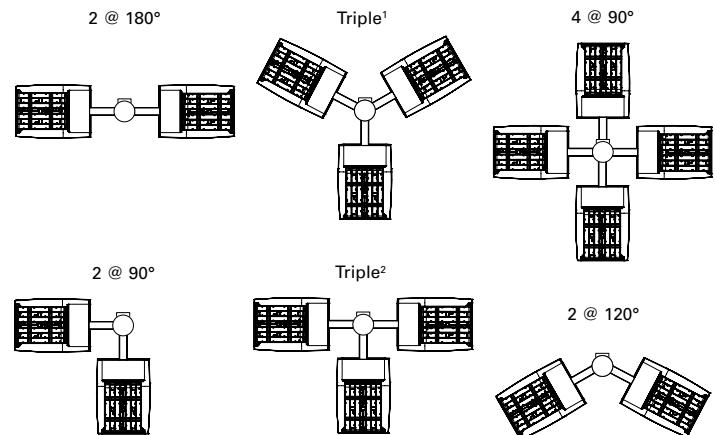


NOTES: 1 Round poles are 3 @ 120°. Square poles are 3 @ 90°. 2 Round poles are 3 @ 90°. 3 Shown with 4 square configurations

Fixture Weights and EPAs

Number of Light Squares	Weight with Standard and Extended Arm (lbs.)	EPA with Standard and Extended Arm (Sq. Ft.)	Weight with QM Arm (lbs.)	EPA with QM Arm (Sq. Ft.)	Weight with QML (lbs.)	EPA with QML (Sq. Ft.)	Weight with QMEA (lbs.)	EPA with QMEA (Sq. Ft.)
1-4	33	0.96	35	1.11	--	--	38	1.11
5-6	44	1.00	46	1.11	--	--	49	1.11
7-8	54	1.07	56	1.11	58	1.11	--	--
9-10	63	1.12	--	--	67	1.11	--	--

Optical Distributions

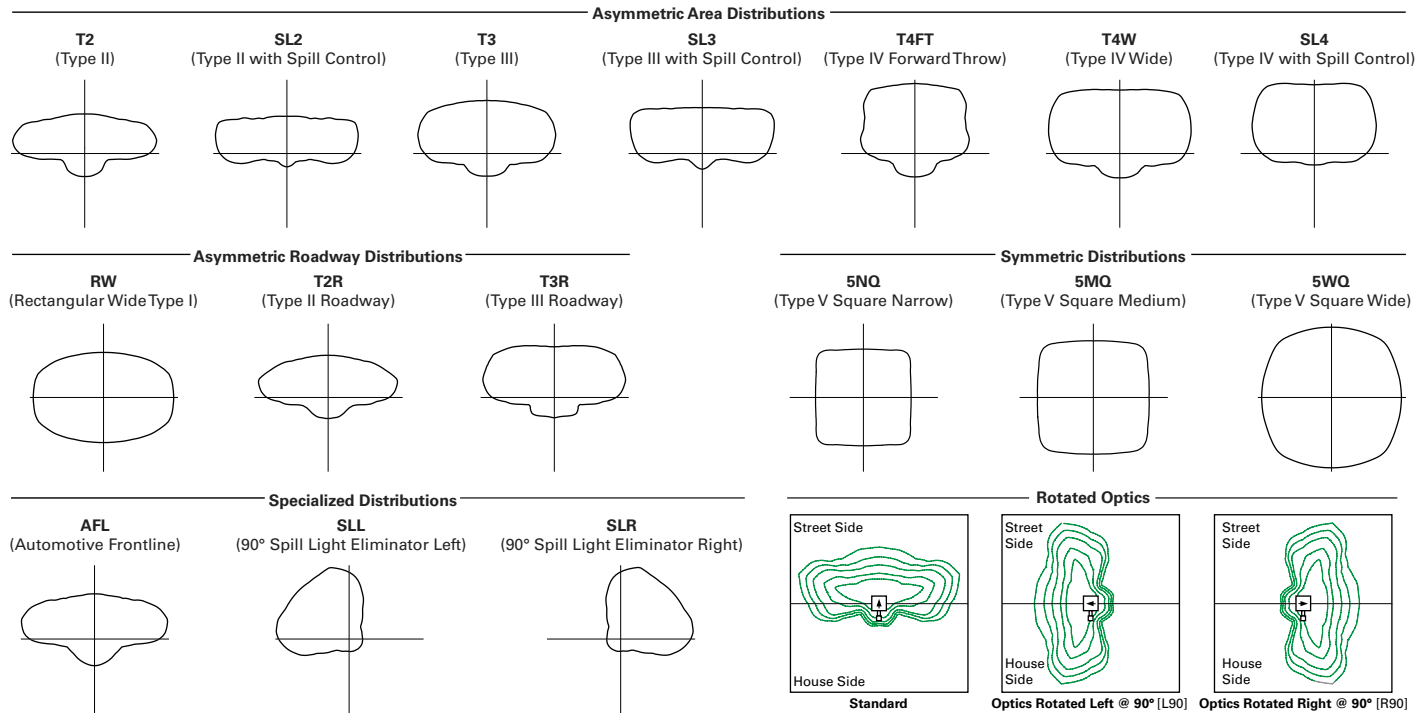

Product Specifications

Construction

- Extruded aluminum driver enclosure
- Heavy-wall, die-cast aluminum end caps
- Die-cast aluminum heat sinks
- Patent pending interlocking housing and heat sink

Optics

- Patented, high-efficiency injection-molded AccuLED Optics technology
- 16 optical distributions
- 3 shielding options including HSS, GRS and PFS
- IDA Certified (3000K CCT and warmer only)

Electrical

- LED drivers are mounted to removable tray assembly for ease of maintenance
- Standard with 0-10V dimming
- Standard with Cooper Lighting Solutions

proprietary circuit module designed to withstand 10kV of transient line surge

- Suitable for operation in -40°C to 40°C ambient environments. Optional 50°C high ambient (HA) configuration.

Mounting

- Standard extruded arm includes internal bolt guides and round pole adapter
- Extended arms (EA and QMEA) may be required in 90° or 120° pole mount configurations, see arm mounting requirements table
- Mast arm (MA) factory installed
- Wall mount (WM) option available
- Quick mount arm (QM and QMEA) includes pole adapter and factory installed fixture mount for fast installation to square or round poles

Finish

- Super housing durable TGIC polyester powder coat paint, 2.5 mil nominal thickness
- Heat sink is powder coated black
- RAL and custom color matches available
- Coastal Construction (CC) option available

Warranty

- Five year limited warranty, consult website for details. www.cooperlighting.com/legal

Energy and Performance Data

Lumen Maintenance (TM-21)

Drive Current	Ambient Temperature	25,000 hours*	50,000 hours*	60,000 hours*	100,000 hours**	Theoretical L70 hours**
Up to 1A	25°C	99.4%	99.0%	98.9%	98.3%	> 2.4M
	40°C	98.7%	98.3%	98.1%	97.4%	> 1.9M
	50°C	98.2%	97.2%	96.8%	95.2%	> 851,000
1.2A	25°C	99.4%	99.0%	98.9%	98.3%	> 2.4M
	40°C	98.5%	97.9%	97.7%	96.7%	> 1.3M

* Supported by IES TM-21 standards

** Theoretical values represent estimations commonly used; however, refer to the IES position on LED Product Lifetime Prediction, IES PS-10-18, explaining proper use of IES TM-21 and LM-80.

Lumen Multiplier

Ambient Temperature	Lumen Multiplier
0°C	1.02
10°C	1.01
25°C	1.00
40°C	0.99
50°C	0.97



View GLEON IES files

Nominal Power Lumens (1.2A)

 Supplemental Performance Guide**

Number of Light Squares		1	2	3	4	5	6	7	8	9	10
Nominal Power (Watts)		67	129	191	258	320	382	448	511	575	640
Input Current @ 120V (A)		0.58	1.16	1.78	2.31	2.94	3.56	4.09	4.71	5.34	5.87
Input Current @ 208V (A)		0.33	0.63	0.93	1.27	1.57	1.87	2.22	2.52	2.8	3.14
Input Current @ 240V (A)		0.29	0.55	0.80	1.10	1.35	1.61	1.93	2.18	2.41	2.71
Input Current @ 277V (A)		0.25	0.48	0.70	0.96	1.18	1.39	1.69	1.90	2.09	2.36
Input Current @ 347V (A)		0.20	0.39	0.57	0.78	0.96	1.15	1.36	1.54	1.72	1.92
Input Current @ 480V (A)		0.15	0.30	0.43	0.60	0.73	0.85	1.03	1.16	1.28	1.45
Optics											
T2	4000K Lumens	7,972	15,580	23,245	30,714	38,056	45,541	53,857	61,024	68,072	75,366
	BUG Rating	B1-U0-G2	B2-U0-G3	B3-U0-G4	B3-U0-G4	B3-U0-G5	B3-U0-G5	B4-U0-G5	B4-U0-G5	B4-U0-G5	B4-U0-G5
	Lumens per Watt	119	121	122	119	119	119	120	119	118	118
T2R	4000K Lumens	8,462	16,539	24,680	32,609	40,401	48,348	57,176	64,783	72,266	80,010
	BUG Rating	B1-U0-G2	B2-U0-G2	B3-U0-G3	B3-U0-G4	B3-U0-G4	B3-U0-G5	B4-U0-G5	B4-U0-G5	B4-U0-G5	B4-U0-G5
	Lumens per Watt	126	128	129	126	126	127	128	127	126	125
T3	4000K Lumens	8,125	15,879	23,693	31,307	38,787	46,417	54,893	62,197	69,381	76,818
	BUG Rating	B1-U0-G2	B2-U0-G3	B3-U0-G4	B3-U0-G4	B3-U0-G5	B4-U0-G5	B4-U0-G5	B4-U0-G5	B4-U0-G5	B4-U0-G5
	Lumens per Watt	121	123	124	121	121	122	123	122	121	120
T3R	4000K Lumens	8,306	16,232	24,220	32,001	39,651	47,447	56,114	63,580	70,924	78,523
	BUG Rating	B1-U0-G2	B2-U0-G3	B3-U0-G4	B3-U0-G4	B3-U0-G5	B3-U0-G5	B4-U0-G5	B4-U0-G5	B4-U0-G5	B4-U0-G5
	Lumens per Watt	124	126	127	124	124	124	125	124	123	123
T4FT	4000K Lumens	8,173	15,970	23,831	31,488	39,014	46,686	55,212	62,558	69,783	77,261
	BUG Rating	B1-U0-G3	B2-U0-G3	B3-U0-G4	B3-U0-G5	B3-U0-G5	B4-U0-G5	B4-U0-G5	B4-U0-G5	B4-U0-G5	B4-U0-G5
	Lumens per Watt	122	124	125	122	122	122	123	122	121	121
T4W	4000K Lumens	8,067	15,764	23,522	31,080	38,510	46,082	54,499	61,751	68,881	76,263
	BUG Rating	B2-U0-G2	B3-U0-G3	B3-U0-G4	B3-U0-G5	B4-U0-G5	B4-U0-G5	B4-U0-G5	B4-U0-G5	B4-U0-G5	B5-U0-G5
	Lumens per Watt	120	122	123	120	120	121	122	121	120	119
SL2	4000K Lumens	7,958	15,552	23,206	30,662	37,989	45,462	53,763	60,920	67,952	75,235
	BUG Rating	B2-U0-G3	B3-U0-G3	B3-U0-G4	B3-U0-G5	B3-U0-G5	B4-U0-G5	B4-U0-G5	B4-U0-G5	B4-U0-G5	B4-U0-G5
	Lumens per Watt	119	121	121	119	119	119	120	119	118	118
SL3	4000K Lumens	8,124	15,877	23,690	31,302	38,784	46,410	54,885	62,189	69,372	76,805
	BUG Rating	B1-U0-G2	B2-U0-G3	B3-U0-G4	B3-U0-G5	B3-U0-G5	B3-U0-G5	B4-U0-G5	B4-U0-G5	B4-U0-G5	B4-U0-G5
	Lumens per Watt	121	123	124	121	121	121	123	122	121	120
SL4	4000K Lumens	7,719	15,085	22,510	29,741	36,850	44,097	52,148	59,089	65,913	72,977
	BUG Rating	B1-U0-G3	B2-U0-G4	B2-U0-G5	B3-U0-G5	B3-U0-G5	B3-U0-G5	B3-U0-G5	B3-U0-G5	B4-U0-G5	B4-U0-G5
	Lumens per Watt	115	117	118	115	115	115	116	116	115	114
5NQ	4000K Lumens	8,380	16,375	24,436	32,287	40,003	47,870	56,610	64,144	71,552	79,221
	BUG Rating	B3-U0-G1	B3-U0-G2	B4-U0-G2	B5-U0-G2	B5-U0-G3	B5-U0-G3	B5-U0-G4	B5-U0-G4	B5-U0-G4	B5-U0-G4
	Lumens per Watt	125	127	128	125	125	125	126	126	124	124
5MQ	4000K Lumens	8,534	16,676	24,885	32,881	40,739	48,752	57,653	65,326	72,868	80,679
	BUG Rating	B3-U0-G2	B4-U0-G2	B5-U0-G3	B5-U0-G4	B5-U0-G4	B5-U0-G4	B5-U0-G5	B5-U0-G5	B5-U0-G5	B5-U0-G5
	Lumens per Watt	127	129	130	127	127	128	129	128	127	126
5WQ	4000K Lumens	8,556	16,723	24,951	32,968	40,847	48,881	57,808	65,499	73,063	80,894
	BUG Rating	B3-U0-G2	B4-U0-G2	B5-U0-G3	B5-U0-G4	B5-U0-G4	B5-U0-G5	B5-U0-G5	B5-U0-G5	B5-U0-G5	B5-U0-G5
	Lumens per Watt	128	130	131	128	128	128	129	128	127	126
SLL/ SLR	4000K Lumens	7,140	13,951	20,817	27,506	34,081	40,783	48,231	54,649	60,959	67,492
	BUG Rating	B1-U0-G3	B2-U0-G3	B3-U0-G4	B3-U0-G5	B3-U0-G5	B3-U0-G5	B3-U0-G5	B4-U0-G5	B4-U0-G5	B4-U0-G5
	Lumens per Watt	107	108	109	107	107	107	108	107	106	105
RW	4000K Lumens	8,304	16,228	24,215	31,994	39,641	47,437	56,100	63,566	70,907	78,504
	BUG Rating	B3-U0-G1	B4-U0-G2	B4-U0-G2	B5-U0-G3	B5-U0-G3	B5-U0-G4	B5-U0-G4	B5-U0-G4	B5-U0-G5	B5-U0-G5
	Lumens per Watt	124	126	127	124	124	124	125	124	123	123
AFL	4000K Lumens	8,335	16,287	24,302	32,110	39,784	47,610	56,303	63,796	71,163	78,790
	BUG Rating	B1-U0-G1	B2-U0-G2	B3-U0-G2	B3-U0-G3	B3-U0-G3	B3-U0-G3	B4-U0-G4	B4-U0-G4	B4-U0-G4	B4-U0-G5
	Lumens per Watt	124	126	127	124	124	125	126	125	124	123

* Nominal data for 70 CRI. ** For additional performance data, please reference the Galleon Supplemental Performance Guide.

Nominal Power Lumens (1A)

 Supplemental Performance Guide**

Number of Light Squares		1	2	3	4	5	6	7	8	9	10
Nominal Power (Watts)		59	113	166	225	279	333	391	445	501	558
Input Current @ 120V (A)		0.51	1.02	1.53	2.03	2.55	3.06	3.56	4.08	4.60	5.07
Input Current @ 208V (A)		0.29	0.56	0.82	1.11	1.37	1.64	1.93	2.19	2.46	2.75
Input Current @ 240V (A)		0.26	0.48	0.71	0.96	1.19	0.41	1.67	1.89	2.12	2.39
Input Current @ 277V (A)		0.23	0.42	0.61	0.83	1.03	1.23	1.45	1.65	1.84	2.09
Input Current @ 347V (A)		0.17	0.32	0.50	0.64	0.82	1.00	1.14	1.32	1.50	1.68
Input Current @ 480V (A)		0.14	0.24	0.37	0.48	0.61	0.75	0.91	0.99	1.12	1.28
Optics											
T2	4000K Lumens	7,267	14,201	21,190	28,000	34,692	41,515	49,096	55,627	62,053	68,703
	BUG Rating	B1-U0-G2	B2-U0-G3	B3-U0-G3	B3-U0-G4	B3-U0-G4	B3-U0-G5	B4-U0-G5	B4-U0-G5	B4-U0-G5	B4-U0-G5
	Lumens per Watt	123	126	128	124	124	125	126	125	124	123
T2R	4000K Lumens	7,715	15,077	22,497	29,725	36,829	44,073	52,122	59,056	65,876	72,937
	BUG Rating	B1-U0-G2	B2-U0-G2	B3-U0-G3	B3-U0-G3	B3-U0-G4	B3-U0-G4	B3-U0-G5	B4-U0-G5	B4-U0-G5	B4-U0-G5
	Lumens per Watt	131	133	136	132	132	132	133	133	131	131
T3	4000K Lumens	7,408	14,475	21,598	28,539	35,358	42,313	50,039	56,698	63,246	70,024
	BUG Rating	B1-U0-G2	B2-U0-G2	B3-U0-G3	B3-U0-G4	B3-U0-G4	B3-U0-G5	B4-U0-G5	B4-U0-G5	B4-U0-G5	B4-U0-G5
	Lumens per Watt	126	128	130	127	127	127	128	127	126	125
T3R	4000K Lumens	7,571	14,798	22,078	29,172	36,145	43,253	51,153	57,959	64,653	71,581
	BUG Rating	B1-U0-G2	B2-U0-G3	B3-U0-G4	B3-U0-G4	B3-U0-G5	B3-U0-G5	B4-U0-G5	B4-U0-G5	B4-U0-G5	B4-U0-G5
	Lumens per Watt	128	131	133	130	130	130	131	130	129	128
T4FT	4000K Lumens	7,451	14,559	21,725	28,703	35,564	42,558	50,330	57,027	63,613	70,430
	BUG Rating	B1-U0-G2	B2-U0-G3	B3-U0-G4	B3-U0-G5	B3-U0-G5	B3-U0-G5	B4-U0-G5	B4-U0-G5	B4-U0-G5	B4-U0-G5
	Lumens per Watt	126	129	131	128	127	128	129	128	127	126
T4W	4000K Lumens	7,354	14,371	21,442	28,333	35,105	42,007	49,681	56,291	62,792	69,521
	BUG Rating	B1-U0-G2	B2-U0-G3	B3-U0-G4	B3-U0-G4	B3-U0-G5	B4-U0-G5	B4-U0-G5	B4-U0-G5	B4-U0-G5	B4-U0-G5
	Lumens per Watt	125	127	129	126	126	126	127	126	125	125
SL2	4000K Lumens	7,254	14,178	21,155	27,951	34,631	41,443	49,011	55,533	61,944	68,584
	BUG Rating	B1-U0-G2	B2-U0-G3	B3-U0-G4	B3-U0-G5	B3-U0-G5	B4-U0-G5	B4-U0-G5	B4-U0-G5	B4-U0-G5	B4-U0-G5
	Lumens per Watt	123	125	127	124	124	124	125	125	124	123
SL3	4000K Lumens	7,406	14,474	21,596	28,534	35,355	42,307	50,033	56,690	63,237	70,014
	BUG Rating	B1-U0-G2	B2-U0-G3	B3-U0-G4	B3-U0-G5	B3-U0-G5	B3-U0-G5	B3-U0-G5	B4-U0-G5	B4-U0-G5	B4-U0-G5
	Lumens per Watt	126	128	130	127	127	127	128	127	126	125
SL4	4000K Lumens	7,037	13,751	20,519	27,112	33,592	40,198	47,538	53,864	60,087	66,524
	BUG Rating	B1-U0-G3	B2-U0-G4	B2-U0-G5	B3-U0-G5	B3-U0-G5	B3-U0-G5	B3-U0-G5	B3-U0-G5	B3-U0-G5	B4-U0-G5
	Lumens per Watt	119	122	124	120	120	121	122	121	120	119
5NQ	4000K Lumens	7,640	14,928	22,275	29,431	36,465	43,637	51,606	58,472	65,226	72,218
	BUG Rating	B3-U0-G1	B3-U0-G2	B4-U0-G2	B5-U0-G2	B5-U0-G3	B5-U0-G3	B5-U0-G4	B5-U0-G4	B5-U0-G4	B5-U0-G4
	Lumens per Watt	129	132	134	131	131	131	132	131	130	129
5MQ	4000K Lumens	7,779	15,203	22,684	29,973	37,137	44,441	52,555	59,549	66,427	73,545
	BUG Rating	B3-U0-G2	B4-U0-G2	B5-U0-G3	B5-U0-G3	B5-U0-G4	B5-U0-G4	B5-U0-G5	B5-U0-G5	B5-U0-G5	B5-U0-G5
	Lumens per Watt	132	135	137	133	133	133	134	134	133	132
5WQ	4000K Lumens	7,800	15,243	22,744	30,052	37,236	44,560	52,697	59,708	66,603	73,742
	BUG Rating	B3-U0-G2	B4-U0-G2	B5-U0-G3	B5-U0-G4	B5-U0-G4	B5-U0-G5	B5-U0-G5	B5-U0-G5	B5-U0-G5	B5-U0-G5
	Lumens per Watt	132	135	137	134	133	134	135	134	133	132
SL/SLR	4000K Lumens	6,510	12,719	18,977	25,075	31,067	37,176	43,967	49,817	55,569	61,525
	BUG Rating	B1-U0-G2	B2-U0-G3	B2-U0-G4	B3-U0-G5	B3-U0-G5	B3-U0-G5	B3-U0-G5	B3-U0-G5	B4-U0-G5	B4-U0-G5
	Lumens per Watt	110	113	114	111	111	112	112	112	111	110
RW	4000K Lumens	7,570	14,793	22,073	29,165	36,137	43,243	51,140	57,945	64,637	71,564
	BUG Rating	B3-U0-G1	B4-U0-G2	B4-U0-G2	B5-U0-G3	B5-U0-G3	B5-U0-G4	B5-U0-G4	B5-U0-G4	B5-U0-G4	B5-U0-G5
	Lumens per Watt	128	131	133	130	130	130	131	130	129	128
AFL	4000K Lumens	7,598	14,847	22,154	29,272	36,267	43,400	51,326	58,156	64,872	71,824
	BUG Rating	B1-U0-G1	B2-U0-G2	B3-U0-G2	B3-U0-G3	B3-U0-G3	B3-U0-G3	B4-U0-G4	B4-U0-G4	B4-U0-G4	B4-U0-G4
	Lumens per Watt	129	131	133	130	130	130	131	131	129	129

* Nominal data for 70 CRI. ** For additional performance data, please reference the Galleon Supplemental Performance Guide.

Nominal Power Lumens (800mA)

 Supplemental Performance Guide**

Number of Light Squares		1	2	3	4	5	6	7	8	9	10
Nominal Power (Watts)		44	85	124	171	210	249	295	334	374	419
Input Current @ 120V (A)		0.39	0.77	1.13	1.54	1.90	2.26	2.67	3.03	3.39	3.80
Input Current @ 208V (A)		0.22	0.44	0.62	0.88	1.06	1.24	1.50	1.68	1.87	2.12
Input Current @ 240V (A)		0.19	0.38	0.54	0.76	0.92	1.08	1.30	1.46	1.62	1.84
Input Current @ 277V (A)		0.17	0.36	0.47	0.72	0.83	0.95	1.19	1.31	1.42	1.67
Input Current @ 347V (A)		0.15	0.24	0.38	0.49	0.63	0.77	0.87	1.01	1.15	1.52
Input Current @ 480V (A)		0.11	0.18	0.29	0.37	0.48	0.59	0.66	0.77	0.88	0.96
Optics											
T2	4000K Lumens	5,871	11,474	17,121	22,622	28,029	33,542	39,667	44,944	50,134	55,508
	BUG Rating	B1-U0-G2	B2-U0-G2	B2-U0-G3	B3-U0-G4	B3-U0-G4	B3-U0-G4	B3-U0-G5	B3-U0-G5	B4-U0-G5	B4-U0-G5
	Lumens per Watt	133	135	138	132	133	135	134	135	134	132
T2R	4000K Lumens	6,233	12,181	18,176	24,016	29,756	35,608	42,111	47,714	53,224	58,929
	BUG Rating	B1-U0-G1	B2-U0-G2	B2-U0-G2	B3-U0-G3	B3-U0-G3	B3-U0-G4	B3-U0-G4	B3-U0-G4	B3-U0-G5	B4-U0-G5
	Lumens per Watt	142	143	147	140	142	143	143	143	142	141
T3	4000K Lumens	5,986	11,695	17,450	23,057	28,568	34,186	40,430	45,809	51,099	56,576
	BUG Rating	B1-U0-G2	B2-U0-G2	B3-U0-G3	B3-U0-G4	B3-U0-G4	B3-U0-G4	B3-U0-G5	B4-U0-G5	B4-U0-G5	B4-U0-G5
	Lumens per Watt	136	138	141	135	136	137	137	137	137	135
T3R	4000K Lumens	6,117	11,955	17,838	23,569	29,203	34,946	41,328	46,827	52,235	57,832
	BUG Rating	B1-U0-G2	B2-U0-G2	B2-U0-G3	B3-U0-G4	B3-U0-G4	B3-U0-G5	B3-U0-G5	B3-U0-G5	B4-U0-G5	B4-U0-G5
	Lumens per Watt	139	141	144	138	139	140	140	140	140	138
T4FT	4000K Lumens	6,019	11,763	17,551	23,190	28,734	34,384	40,663	46,074	51,396	56,904
	BUG Rating	B1-U0-G2	B2-U0-G3	B3-U0-G4	B3-U0-G4	B3-U0-G5	B3-U0-G5	B3-U0-G5	B4-U0-G5	B4-U0-G5	B4-U0-G5
	Lumens per Watt	137	138	142	136	137	138	138	138	137	136
T4W	4000K Lumens	5,942	11,610	17,324	22,891	28,363	33,940	40,138	45,480	50,732	56,169
	BUG Rating	B1-U0-G2	B2-U0-G2	B3-U0-G3	B3-U0-G4	B3-U0-G4	B3-U0-G5	B4-U0-G5	B4-U0-G5	B4-U0-G5	B4-U0-G5
	Lumens per Watt	135	137	140	134	135	136	136	136	136	134
SL2	4000K Lumens	5,862	11,454	17,091	22,583	27,980	33,484	39,598	44,867	50,048	55,411
	BUG Rating	B1-U0-G2	B2-U0-G3	B3-U0-G4	B3-U0-G4	B3-U0-G5	B3-U0-G5	B4-U0-G5	B4-U0-G5	B4-U0-G5	B4-U0-G5
	Lumens per Watt	133	135	138	132	133	134	134	134	134	132
SL3	4000K Lumens	5,985	11,694	17,447	23,053	28,565	34,182	40,424	45,804	51,092	56,568
	BUG Rating	B1-U0-G2	B2-U0-G3	B2-U0-G3	B3-U0-G4	B3-U0-G5	B3-U0-G5	B3-U0-G5	B3-U0-G5	B3-U0-G5	B4-U0-G5
	Lumens per Watt	136	138	141	135	136	137	137	137	137	135
SL4	4000K Lumens	5,685	11,111	16,577	21,905	27,140	32,478	38,409	43,520	48,546	53,748
	BUG Rating	B1-U0-G2	B1-U0-G3	B2-U0-G4	B2-U0-G5	B3-U0-G5	B3-U0-G5	B3-U0-G5	B3-U0-G5	B3-U0-G5	B3-U0-G5
	Lumens per Watt	129	131	134	128	129	130	130	130	130	128
5NQ	4000K Lumens	6,172	12,061	17,997	23,778	29,462	35,256	41,694	47,242	52,699	58,347
	BUG Rating	B2-U0-G1	B3-U0-G1	B4-U0-G2	B4-U0-G2	B5-U0-G2	B5-U0-G3	B5-U0-G3	B5-U0-G3	B5-U0-G4	B5-U0-G4
	Lumens per Watt	140	142	145	139	140	142	141	141	141	139
5MQ	4000K Lumens	6,285	12,283	18,328	24,217	30,004	35,907	42,462	48,112	53,669	59,421
	BUG Rating	B3-U0-G1	B4-U0-G2	B4-U0-G2	B5-U0-G3	B5-U0-G3	B5-U0-G4	B5-U0-G4	B5-U0-G4	B5-U0-G5	B5-U0-G5
	Lumens per Watt	143	145	148	142	143	144	144	144	144	142
5WQ	4000K Lumens	6,303	12,317	18,377	24,281	30,085	36,001	42,575	48,241	53,812	59,579
	BUG Rating	B3-U0-G1	B4-U0-G2	B5-U0-G3	B5-U0-G3	B5-U0-G4	B5-U0-G4	B5-U0-G5	B5-U0-G5	B5-U0-G5	B5-U0-G5
	Lumens per Watt	143	145	148	142	143	145	144	144	144	142
SLL/ SLR	4000K Lumens	5,260	10,276	15,332	20,259	25,101	30,037	35,522	40,249	44,898	49,708
	BUG Rating	B1-U0-G2	B2-U0-G3	B2-U0-G4	B3-U0-G4	B3-U0-G5	B3-U0-G5	B3-U0-G5	B3-U0-G5	B3-U0-G5	B3-U0-G5
	Lumens per Watt	120	121	124	118	120	121	120	121	120	119
RW	4000K Lumens	6,116	11,952	17,834	23,563	29,196	34,938	41,317	46,817	52,224	57,819
	BUG Rating	B3-U0-G1	B3-U0-G2	B4-U0-G2	B4-U0-G2	B5-U0-G3	B5-U0-G3	B5-U0-G3	B5-U0-G4	B5-U0-G4	B5-U0-G4
	Lumens per Watt	139	141	144	138	139	140	140	140	140	138
AFL	4000K Lumens	6,139	11,996	17,899	23,650	29,302	35,064	41,468	46,987	52,412	58,030
	BUG Rating	B1-U0-G1	B2-U0-G2	B2-U0-G2	B3-U0-G2	B3-U0-G3	B3-U0-G3	B3-U0-G3	B3-U0-G3	B4-U0-G4	B4-U0-G4
	Lumens per Watt	140	141	144	138	140	141	141	141	140	138

* Nominal data for 70 CRI. ** For additional performance data, please reference the Galleon Supplemental Performance Guide.

Nominal Power Lumens (600mA)

 Supplemental Performance Guide**

Number of Light Squares		1	2	3	4	5	6	7	8	9	10
Nominal Power (Watts)		34	66	96	129	162	193	226	257	290	323
Input Current @ 120V (A)		0.30	0.58	0.86	1.16	1.44	1.73	2.03	2.33	2.59	2.89
Input Current @ 208V (A)		0.17	0.34	0.49	0.65	0.84	0.99	1.14	1.30	1.48	1.63
Input Current @ 240V (A)		0.15	0.30	0.43	0.56	0.74	0.87	1.00	1.13	1.30	1.43
Input Current @ 277V (A)		0.14	0.28	0.41	0.52	0.69	0.81	0.93	1.04	1.22	1.33
Input Current @ 347V (A)		0.11	0.19	0.30	0.39	0.49	0.60	0.69	0.77	0.90	0.99
Input Current @ 480V (A)		0.08	0.15	0.24	0.30	0.38	0.48	0.53	0.59	0.71	0.77
Optics											
T2	4000K Lumens	4,787	9,357	13,961	18,448	22,856	27,353	32,347	36,651	40,884	45,265
	BUG Rating	B1-U0-G1	B2-U0-G2	B2-U0-G3	B2-U0-G3	B3-U0-G4	B3-U0-G4	B3-U0-G4	B3-U0-G5	B3-U0-G5	B3-U0-G5
	Lumens per Watt	141	142	145	143	141	142	143	143	141	140
T2R	4000K Lumens	5,083	9,934	14,822	19,585	24,266	29,038	34,341	38,911	43,404	48,055
	BUG Rating	B1-U0-G1	B1-U0-G2	B2-U0-G2	B2-U0-G2	B3-U0-G3	B3-U0-G3	B3-U0-G4	B3-U0-G4	B3-U0-G4	B3-U0-G5
	Lumens per Watt	150	151	154	152	150	150	152	151	150	149
T3	4000K Lumens	4,880	9,537	14,231	18,803	23,296	27,878	32,970	37,358	41,671	46,137
	BUG Rating	B1-U0-G1	B2-U0-G2	B2-U0-G2	B3-U0-G3	B3-U0-G4	B3-U0-G4	B3-U0-G4	B3-U0-G5	B3-U0-G5	B4-U0-G5
	Lumens per Watt	144	145	148	146	144	144	146	145	144	143
T3R	4000K Lumens	4,988	9,749	14,547	19,220	23,814	28,497	33,703	38,188	42,598	47,162
	BUG Rating	B1-U0-G2	B1-U0-G2	B2-U0-G3	B2-U0-G3	B3-U0-G4	B3-U0-G4	B3-U0-G5	B3-U0-G5	B3-U0-G5	B3-U0-G5
	Lumens per Watt	147	148	152	149	147	148	149	149	147	146
T4FT	4000K Lumens	4,909	9,591	14,312	18,911	23,432	28,040	33,161	37,574	41,913	46,404
	BUG Rating	B1-U0-G2	B2-U0-G3	B2-U0-G3	B3-U0-G4	B3-U0-G4	B3-U0-G5	B3-U0-G5	B3-U0-G5	B3-U0-G5	B4-U0-G5
	Lumens per Watt	144	145	149	147	145	145	147	146	145	144
T4W	4000K Lumens	4,845	9,468	14,128	18,668	23,130	27,678	32,732	37,088	41,371	45,805
	BUG Rating	B1-U0-G2	B2-U0-G2	B2-U0-G3	B3-U0-G3	B3-U0-G4	B3-U0-G4	B3-U0-G5	B3-U0-G5	B4-U0-G5	B4-U0-G5
	Lumens per Watt	143	143	147	145	143	143	145	144	143	142
SL2	4000K Lumens	4,779	9,341	13,937	18,416	22,818	27,305	32,292	36,589	40,813	45,188
	BUG Rating	B1-U0-G2	B2-U0-G3	B2-U0-G3	B3-U0-G4	B3-U0-G4	B3-U0-G5	B3-U0-G5	B3-U0-G5	B4-U0-G5	B4-U0-G5
	Lumens per Watt	141	142	145	143	141	141	143	142	141	140
SL3	4000K Lumens	4,879	9,536	14,229	18,800	23,294	27,874	32,965	37,351	41,666	46,130
	BUG Rating	B1-U0-G2	B1-U0-G3	B2-U0-G3	B2-U0-G4	B3-U0-G4	B3-U0-G5	B3-U0-G5	B3-U0-G5	B3-U0-G5	B3-U0-G5
	Lumens per Watt	144	144	148	146	144	144	146	145	144	143
SL4	4000K Lumens	4,637	9,059	13,519	17,863	22,132	26,486	31,322	35,490	39,589	43,831
	BUG Rating	B1-U0-G2	B1-U0-G3	B2-U0-G4	B2-U0-G4	B2-U0-G5	B3-U0-G5	B3-U0-G5	B3-U0-G5	B3-U0-G5	B3-U0-G5
	Lumens per Watt	136	137	141	138	137	137	139	138	137	136
5NQ	4000K Lumens	5,033	9,835	14,676	19,392	24,026	28,751	34,002	38,526	42,975	47,581
	BUG Rating	B2-U0-G1	B3-U0-G1	B3-U0-G2	B4-U0-G2	B4-U0-G2	B4-U0-G2	B5-U0-G2	B5-U0-G3	B5-U0-G3	B5-U0-G3
	Lumens per Watt	148	149	153	150	148	149	150	150	148	147
5MQ	4000K Lumens	5,126	10,015	14,946	19,747	24,468	29,281	34,628	39,236	43,766	48,457
	BUG Rating	B3-U0-G1	B3-U0-G2	B4-U0-G2	B4-U0-G2	B5-U0-G3	B5-U0-G3	B5-U0-G4	B5-U0-G4	B5-U0-G4	B5-U0-G4
	Lumens per Watt	151	152	156	153	151	152	153	153	151	150
5WQ	4000K Lumens	5,139	10,043	14,985	19,801	24,533	29,359	34,721	39,339	43,883	48,586
	BUG Rating	B3-U0-G1	B4-U0-G2	B4-U0-G2	B5-U0-G3	B5-U0-G3	B5-U0-G4	B5-U0-G4	B5-U0-G4	B5-U0-G5	B5-U0-G5
	Lumens per Watt	151	152	156	153	151	152	154	153	151	150
SLL/ SLR	4000K Lumens	4,289	8,380	12,502	16,520	20,469	24,494	28,967	32,823	36,613	40,537
	BUG Rating	B1-U0-G2	B1-U0-G3	B2-U0-G3	B2-U0-G4	B3-U0-G4	B3-U0-G5	B3-U0-G5	B3-U0-G5	B3-U0-G5	B3-U0-G5
	Lumens per Watt	126	127	130	128	126	127	128	128	126	126
RW	4000K Lumens	4,987	9,746	14,543	19,215	23,808	28,491	33,695	38,178	42,587	47,151
	BUG Rating	B2-U0-G1	B3-U0-G1	B4-U0-G2	B4-U0-G2	B4-U0-G2	B5-U0-G3	B5-U0-G3	B5-U0-G3	B5-U0-G4	B5-U0-G4
	Lumens per Watt	147	148	151	149	147	148	149	149	147	146
AFL	4000K Lumens	5,007	9,782	14,597	19,285	23,896	28,594	33,817	38,317	42,742	47,322
	BUG Rating	B1-U0-G1	B1-U0-G1	B2-U0-G2	B2-U0-G2	B3-U0-G2	B3-U0-G3	B3-U0-G3	B3-U0-G3	B3-U0-G3	B3-U0-G3
	Lumens per Watt	147	148	152	149	148	148	150	149	147	147

* Nominal data for 70 CRI. ** For additional performance data, please reference the Galleon Supplemental Performance Guide.

Control Options

0-10V (DIM)

This fixture is offered standard with 0-10V dimming driver(s). The DIM option provides 0-10V dimming wire leads for use with a lighting control panel or other control method.

Photocontrol (BPC, PR and PR7)




Optional button-type photocontrol (BPC) and photocontrol receptacles (PR and PR7) provide a flexible solution to enable "dusk-to-dawn" lighting by sensing light levels. Advanced control systems compatible with NEMA 7-pin standards can be utilized with the PR7 receptacle.

After Hours Dim (AHD)

This feature allows photocontrol-enabled luminaires to achieve additional energy savings by dimming during scheduled portions of the night. The dimming profile will automatically take effect after a "dusk-to-dawn" period has been calculated from the photocontrol input. Specify the desired dimming profile for a simple, factory-shipped dimming solution requiring no external control wiring. Reference the After Hours Dim supplemental guide for additional information.



Dimming Occupancy Sensor (SPB, MS/DIM-LXX, MS/X-LXX and MS-LXX)

These sensors are factory installed in the luminaire housing. When the SPB or MS/DIM sensor options are selected, the occupancy sensor is connected to a dimming driver and the entire luminaire dims when there is no activity detected. When activity is detected, the luminaire returns to full light output. The MS/DIM sensor is factory preset to dim down to approximately 50 percent power with a time delay of five minutes. The MS-LXX sensor is factory preset to turn the luminaire off after five minutes of no activity. The MS/X-LXX is also preset for five minutes and only controls the specified number of light engines to maintain steady output from the remaining light engines. SPB motion sensors require the Sensor Configuration mobile application by Wattstopper to change factory default dimming level, time delay, sensitivity and other parameters. Available for iOS and Android devices. The SPB sensor is factory preset to dim down to approximately 10% power with a time delay of five minutes. The MS/DIM occupancy sensors require the FSIR-100 programming tool to adjust factory defaults.

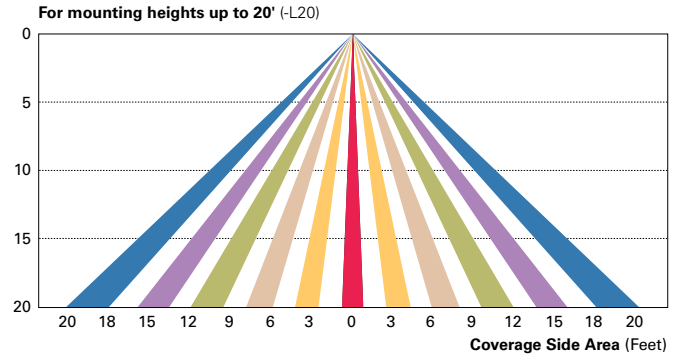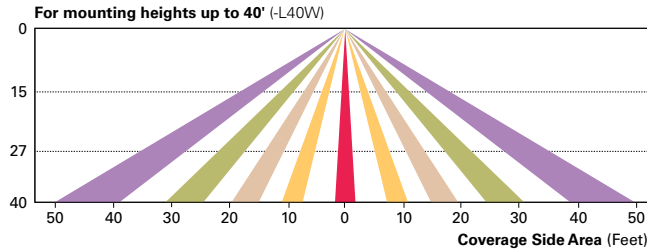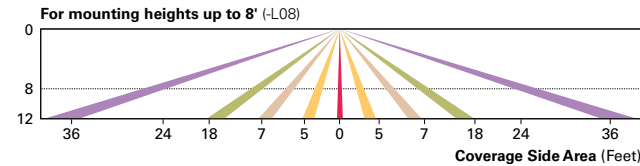

Enlighted Wireless Control and Monitoring System (LWR-LW and LWR-LN)

Enlighted is a connected lighting solution that combines a broad selection of energy-efficient LED luminaires with a powerful integrated wireless sensor system. The sensor controls the lighting system in compliance with the latest energy codes and collects valuable data about building performance and use. Software applications turn the granular data into information through energy dashboards and specialized apps that make it simple and help optimize the use of building resources, beyond lighting.

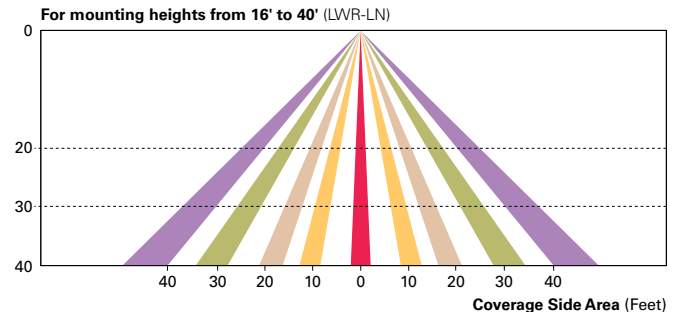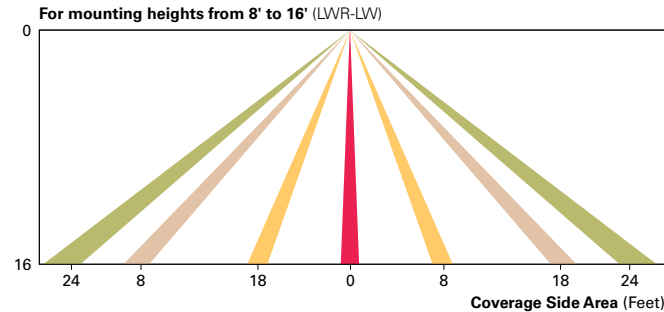

WaveLinx Wireless Outdoor Lighting Control Module (WOLC-7P-10A)

The 7-pin wireless outdoor lighting control module enables WaveLinx to control outdoor area, site and flood lighting. WaveLinx controls outdoor lighting using schedules to provide ON, OFF and dimming controls based on astronomic or time schedules based on a 7 day week.

AirMesh (DIM10)

AirMesh integrated wireless controls system includes factory installed DIM10 Synapse control module and FSP-201 motion sensor, requires additional AirMesh components for operation. Contact Synapse at www.synapsewireless.com for product support, warranty and terms and conditions.